

討論文件

中西區環工會文件第 47/2014 號

關注掘路工程 - 香港電燈有限公司(桂香街 1-13 號/正街/皇后大道西)

背景

就日前香港電燈有限公司致中西區區議會的信件，表示計劃於2014年6月於桂香街1-13號/正街/皇后大道西進行掘路工程，以鋪設低壓電纜，預計完工日期為2015年8月。就此，請有關政府部門及香港電燈有限公司回答以下問題。(詳情請參考附件-香港電燈有限公司的信件及工程草擬圖)

問題

1. 請問香港電燈有限公司是何時開始有上述鋪設低壓電纜計劃，為何會突然於 5 月中提出，需要 6 月份立刻施工？請介紹工程之必要性及迫切性。
2. 請有關部門就工程分為 20 多個階段進行詳列出每一階段的工程時間表，可否縮減工程的進行時間？
3. 請問有關部門有否就工程對附近樓宇的噪音、衛生環境等影響作出評估及是否有諮詢附近居民？
4. 請問有關部門有否就工程對附近交通影響作出評估？此外，有關部門會否協調現場的交通以確保交通暢通？

文件提交人

李志恒

2014 年 5 月 19 日
(秘書處在 5 月 22 日收到)

香港電燈有限公司
The Hongkong Electric Co., Ltd.

香港堅尼地道四十四號港燈中心
Hongkong Electric Centre, 44 Kennedy Road, Hong Kong
電話 / Tel 2843 3111 傳真 / Fax 2810 0506
電郵 / Email mail@hkelectric.com
www.hkelectric.com



本檔案編號：T&D/841/ K/0422 (W/14/0003)

中西區區議會
香港中環統一碼頭道38號
香港政府大樓11樓

敬啟者,

擬在桂香街 1-13 號 / 正街 / 皇后大道西進行挖掘工程
挖掘申請編號: 1139837, 參考編號: W/14/0003

為配合新供電予上述地點，本公司擬於 2014 年 6 月在附圖位置進行挖掘工程以敷設低壓電纜(路政署申請挖掘參考編號: W/14/0003)，並預計工程於 2015 年 8 月完成。

懇請 貴會就此工程擬案於 2014 年 5 月 30 日前給予意見回覆以便策劃。

若 閣下對上述工程有任何查詢，請致電 與本公司 聯絡。

香港電燈有限公司
配電策劃部總工程師
謹啟

附件：挖掘位置圖

二零一四年五月十五日

NCT/

香港電燈有限公司
The Hongkong Electric Co., Ltd.

香港堅尼地道四十四號港燈中心
Hongkong Electric Centre, 44 Kennedy Road, Hong Kong
電話 / Tel 2843 3111 傳真 / Fax 2810 0506
電郵 / Email mail@hkelectric.com
www.hkelectric.com



Our Ref.: T&D/841/K/0422 (W/14/0003)

25th March 2014

Please refer to Distribution List

Dear Sir,

NOTIFICATION OF TRENCH OPENING AT CENTRE STREET,
1-13 KWAI HEUNG STREET
PLAN ID: 1139837, PLAN REF: W/14/0003

Pursuant to the procedures of Excavation Permit Management System (XPMS) of Highways Department, we wish to inform you that it is necessary to excavate in above location as indicated on the enclosed drawing to improve electricity supply to the above area and provide electricity supply to the new residential development at 1-13 Kwai Heung Street. We submit herewith our Temporary Traffic Measures (TTM) for your comment.

The tentative commencement and completion dates of our proposed work will be on 11th June 2014 and 13th August 2015 respectively and subject to the approval of our temporary traffic measures proposal from Transport Department and Hong Kong Police.

The work will be carried out in a workmanlike manner and any inconvenience will be kept to a minimum.

We shall be grateful if you will return your comment to us as soon as possible.

Should you have any queries regarding the above or require any further information, please contact our telephone No.

Yours faithfully,

CHIEF DISTRIBUTION PLANNING ENGINEER

Encl
NCT/


c.c. Highways Department,
Urban Region, Excavation Permit Section,
7-8/F., North Point Government Offices Building,
333 Java Road,
North Point,
Hong Kong
Attn: Mr. K.M. Lo/ IOW/XP (HNW2)

Distribution List:

The Councillor of Central & Western District Council
11/F., Harbour Building,
38 Pier Road,
Central,
Hong Kong



Central and Western District Office
11 & 14/F., Harbour Building,
38 Pier Road,
Central,
Hong Kong

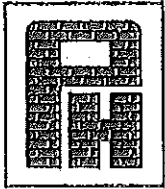

培興工程有限公司
PUI HING CONSTRUCTION CO., LTD.

葵涌葵榮路13-19號偉業工業大廈2樓B室
Flat B, 2/F, Kam Bun Industrial Building,
13-19 Kwai Wing Road, Kwai Chung, N.T.
Tel: (852) 2553 3198 Fax: (852) 2580 0705



ISO 9001 : 2000
Certificate No.: CC 687

TTM for Trenching Works

AT

1 – 13 Kwai Heung Street

Sketch No.: W/14/0003

Plan I.D.: 1134837

Prepared by :

Checked by :

Company Chop :

Date : 25 February 2014



培興工程有限公司
PUI HING CONSTRUCTION CO., LTD.

葵涌葵榮路13-19號錦濱工業大廈2樓B室
Flat B, 2/F, Kam Bun Industrial Building,
13-19 Kwai Wing Road, Kwai Chung, N.T.
Tel : (852) 2553 3198 Fax : (852) 2580 0705



ISO 9001 : 2000
Certificate No.: CC 687

Date : 25 February 2014
Our Plan Ref. : W/14/0003

Temporary Traffic Measures (TTM) Scheme for Road Opening at
1 – 13 Kwai Heung Street

Please find enclosed TTM scheme for the captioned location. Based on the road layout, a temporary traffic measures scheme is proposed as follows:

1. We are going to apply the excavation permit from HyD for trench excavation for installation of distribution cables with approximate trench length of 206m on footpath and 125m on carriageway. The tentative commencement date of work will be 11 April 2014.
2. All trench work will only be carried out between 08:00 & 18:00 for pedestrian and 09:00 & 18:00 for carriageway from Monday to Saturday. No excavation works will be carried out on Sunday and Public Holidays. Steel plate decking will be provided to maintain normal vehicular flow and wooden board decking/plastic trench cover to maintain normal pedestrian flow during non-working hours.
3. Works to comply with Code of Practice for the L, S and G of Road Works.
4. Working area will be properly fenced off complying with HyD's Standard.
5. In Phase 1, 2 & 4, the provision of 1.2m wide of footpath will be maintained for pedestrian flow during the course of works.
6. In Phase 3, the provision of 1.5m wide of footpath requirement may not meet. We are proposed the pedestrian diverted to use carriageway. Decking will be provided for shop entrance and railing will be removed as shown at the attached sketches during the course of works.
7. In Phase 5 & 6, the provision of 1.2m wide of footpath will be maintained for pedestrian flow and decking will be provided for shop entrance during the course of works.
8. In Phase 7 to 10, the provision of 1.5m wide of footpath requirement may not meet. We are proposed the pedestrian diverted to use opposite footway by using the sign 'PLEASE USE OPPOSITE WALKWAY' and decking will be provided for shop entrance during the course of works.
9. In Phase 11, the provision of 1.5m wide of footpath will be maintained for pedestrian flow and decking will be provided for shop entrance during the course of works.
10. In Phase 12 & 13, one lane will be closed for excavation work on carriageway. As least 7m wide will be maintained for vehicular flow and road marking will be revised as shown at the attached sketches during the course of works.
11. In Phase 14 & 15, one lane will be closed for excavation work on carriageway. As least 7m wide will be maintained for vehicular flow during the course of works.
12. In Phase 16 to 22, half lane will be closed for excavation work on carriageway. As least 3m wide will be maintained for vehicular flow during the course of works.
13. Street furniture within our fenced off area may be temporarily removed to facilitate the construction work.
14. Excavated debris will be removed from the construction site at the end of each working day.
15. We expect to complete all works within 314 working days.



培興工程有限公司
PUI HING CONSTRUCTION CO., LTD.

葵涌葵榮路13-19號偉漢工業大廈2樓B室
Flat B, 2/F, Kam Bun Industrial Building,
13-19 Kwai Wing Road, Kwai Chung, N.T.
Tel : (852) 2553 3198 Fax : (852) 2580 0705




088
ISO 9001 : 2000
Certificate No.: CC 687


16. The temporary traffic measures scheme will also submit to Police Traffic for endorsement before our works commencement.

17. For any enquiry regarding this TTM, please contact our _____ at Tel. no. _____.

We will be much grateful if we could have your comments before our submitting to Highways Department for the application of excavation permit.

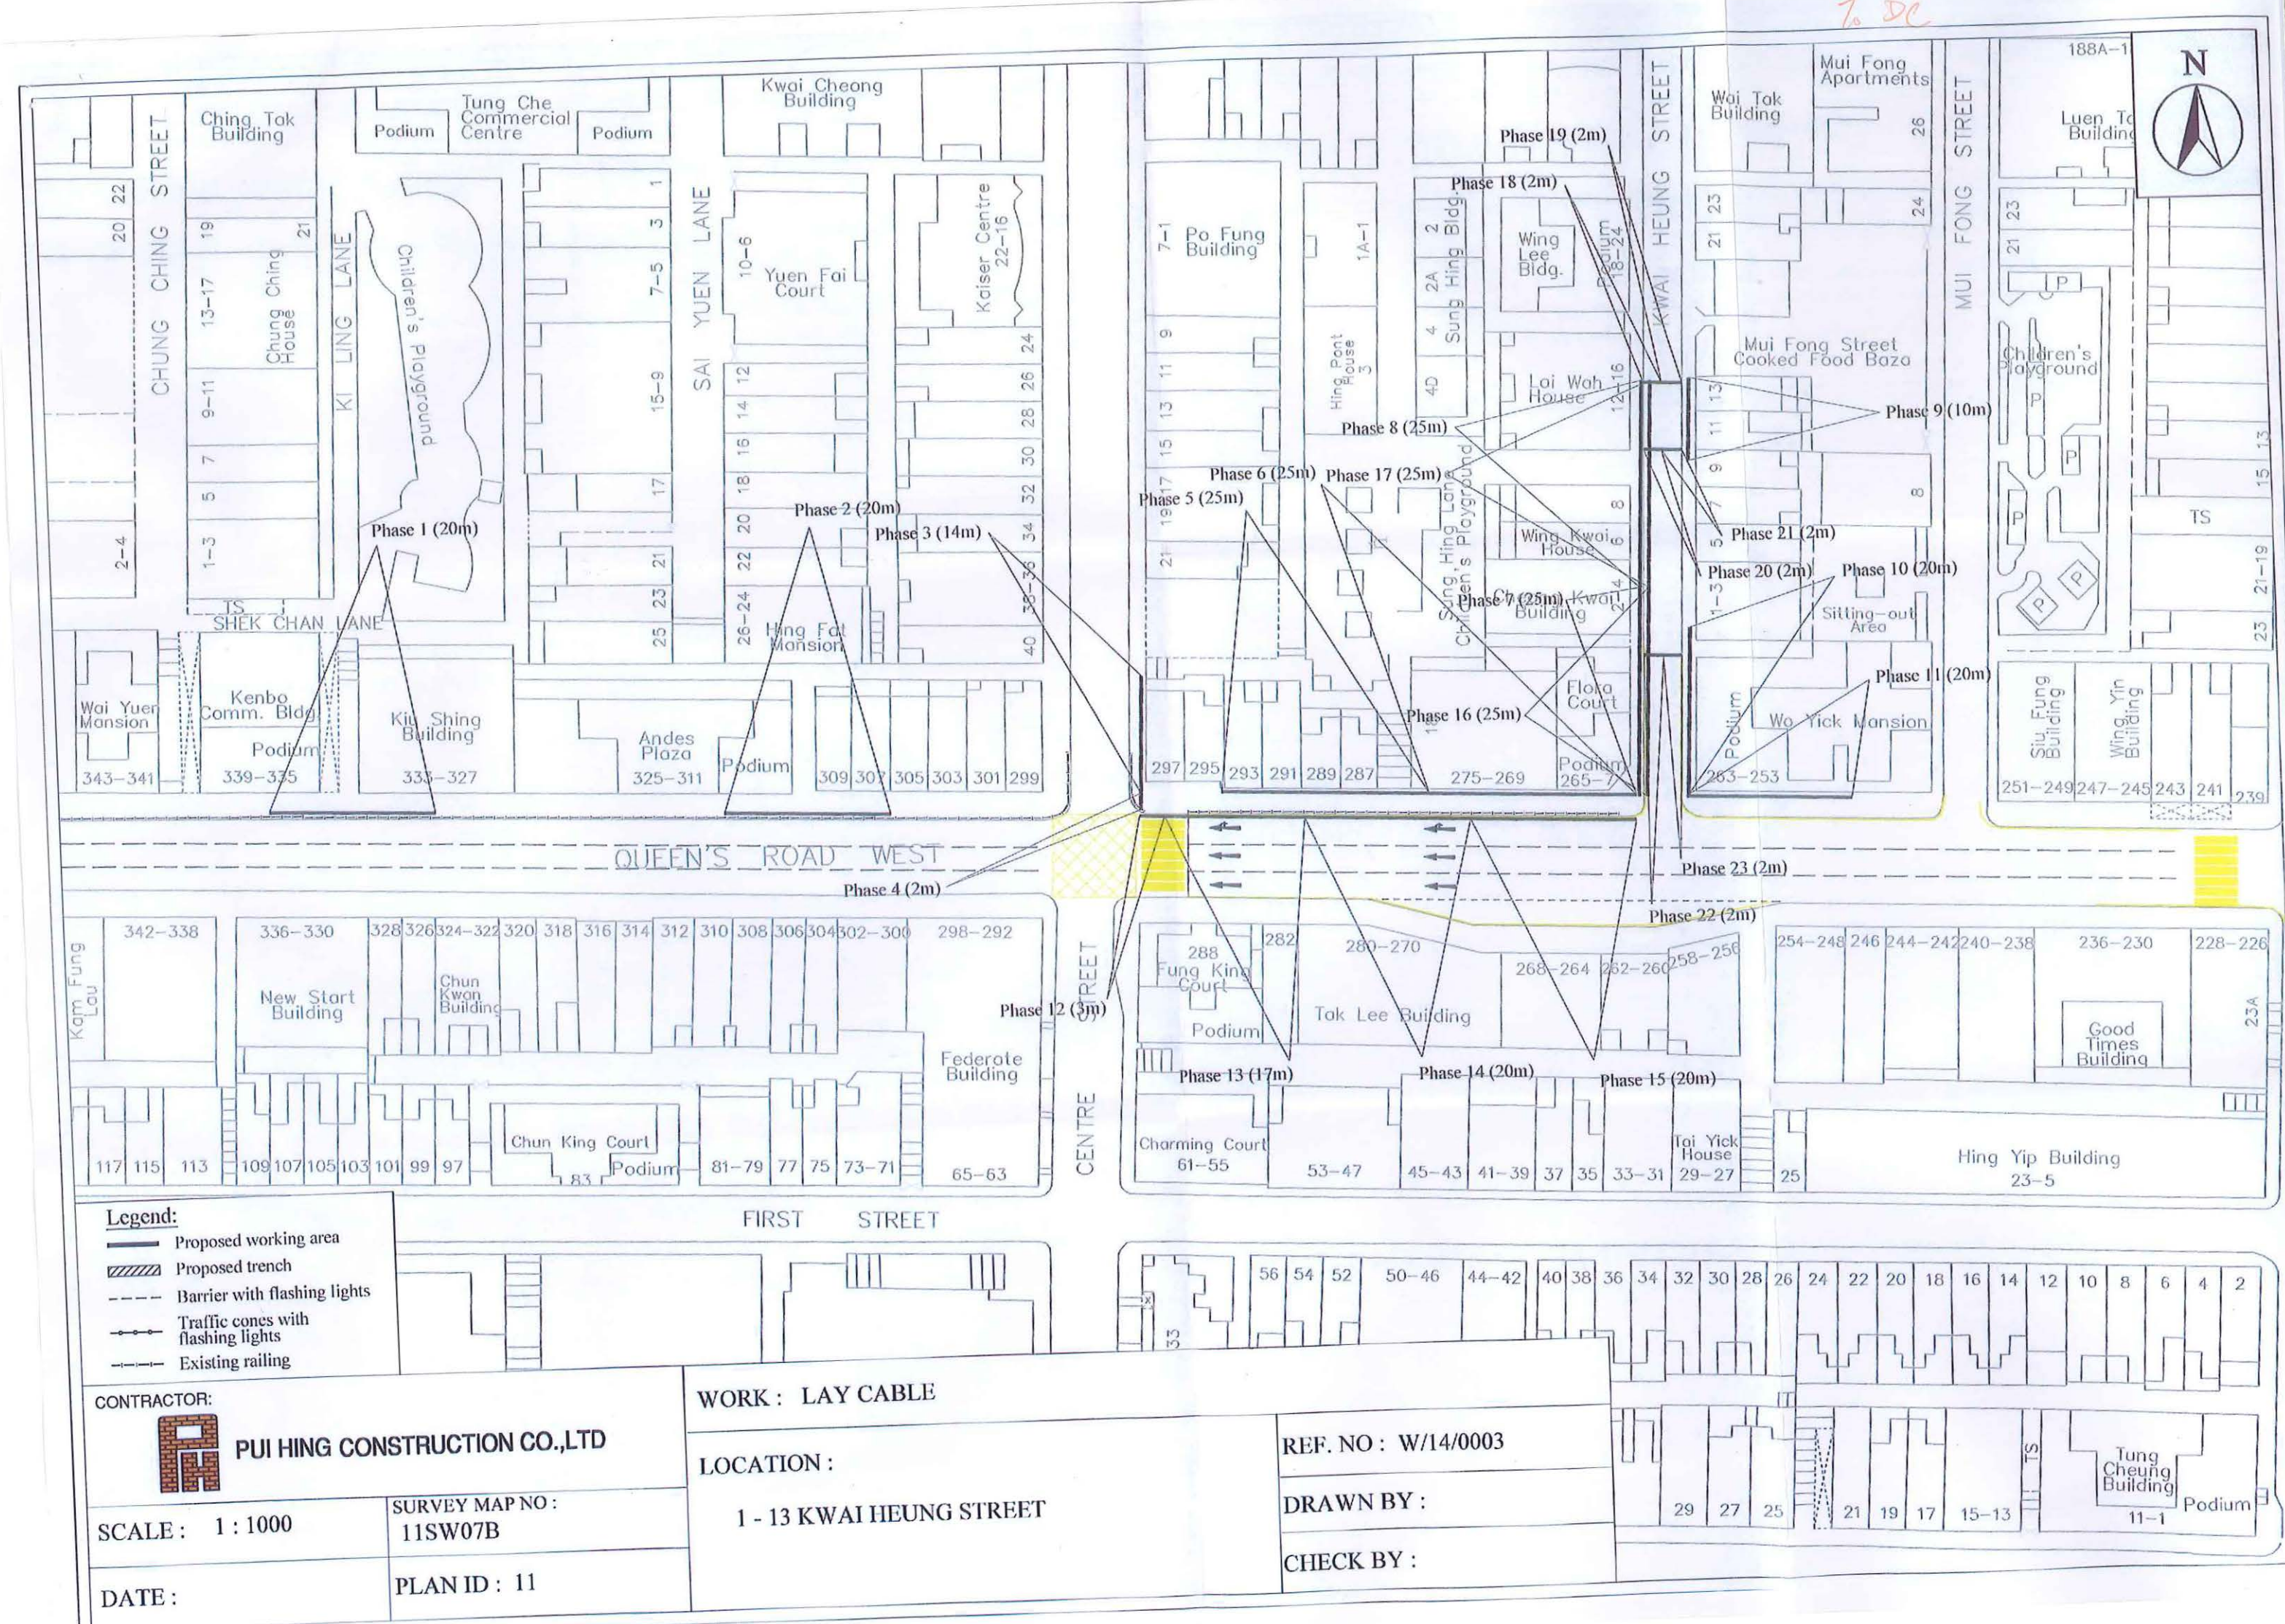

The lightings, signings and guardings arrangement may be deviated from proposed due to site situation but the above arrangement will be comply with Code of Practice for the L, S, and G of Road Works.

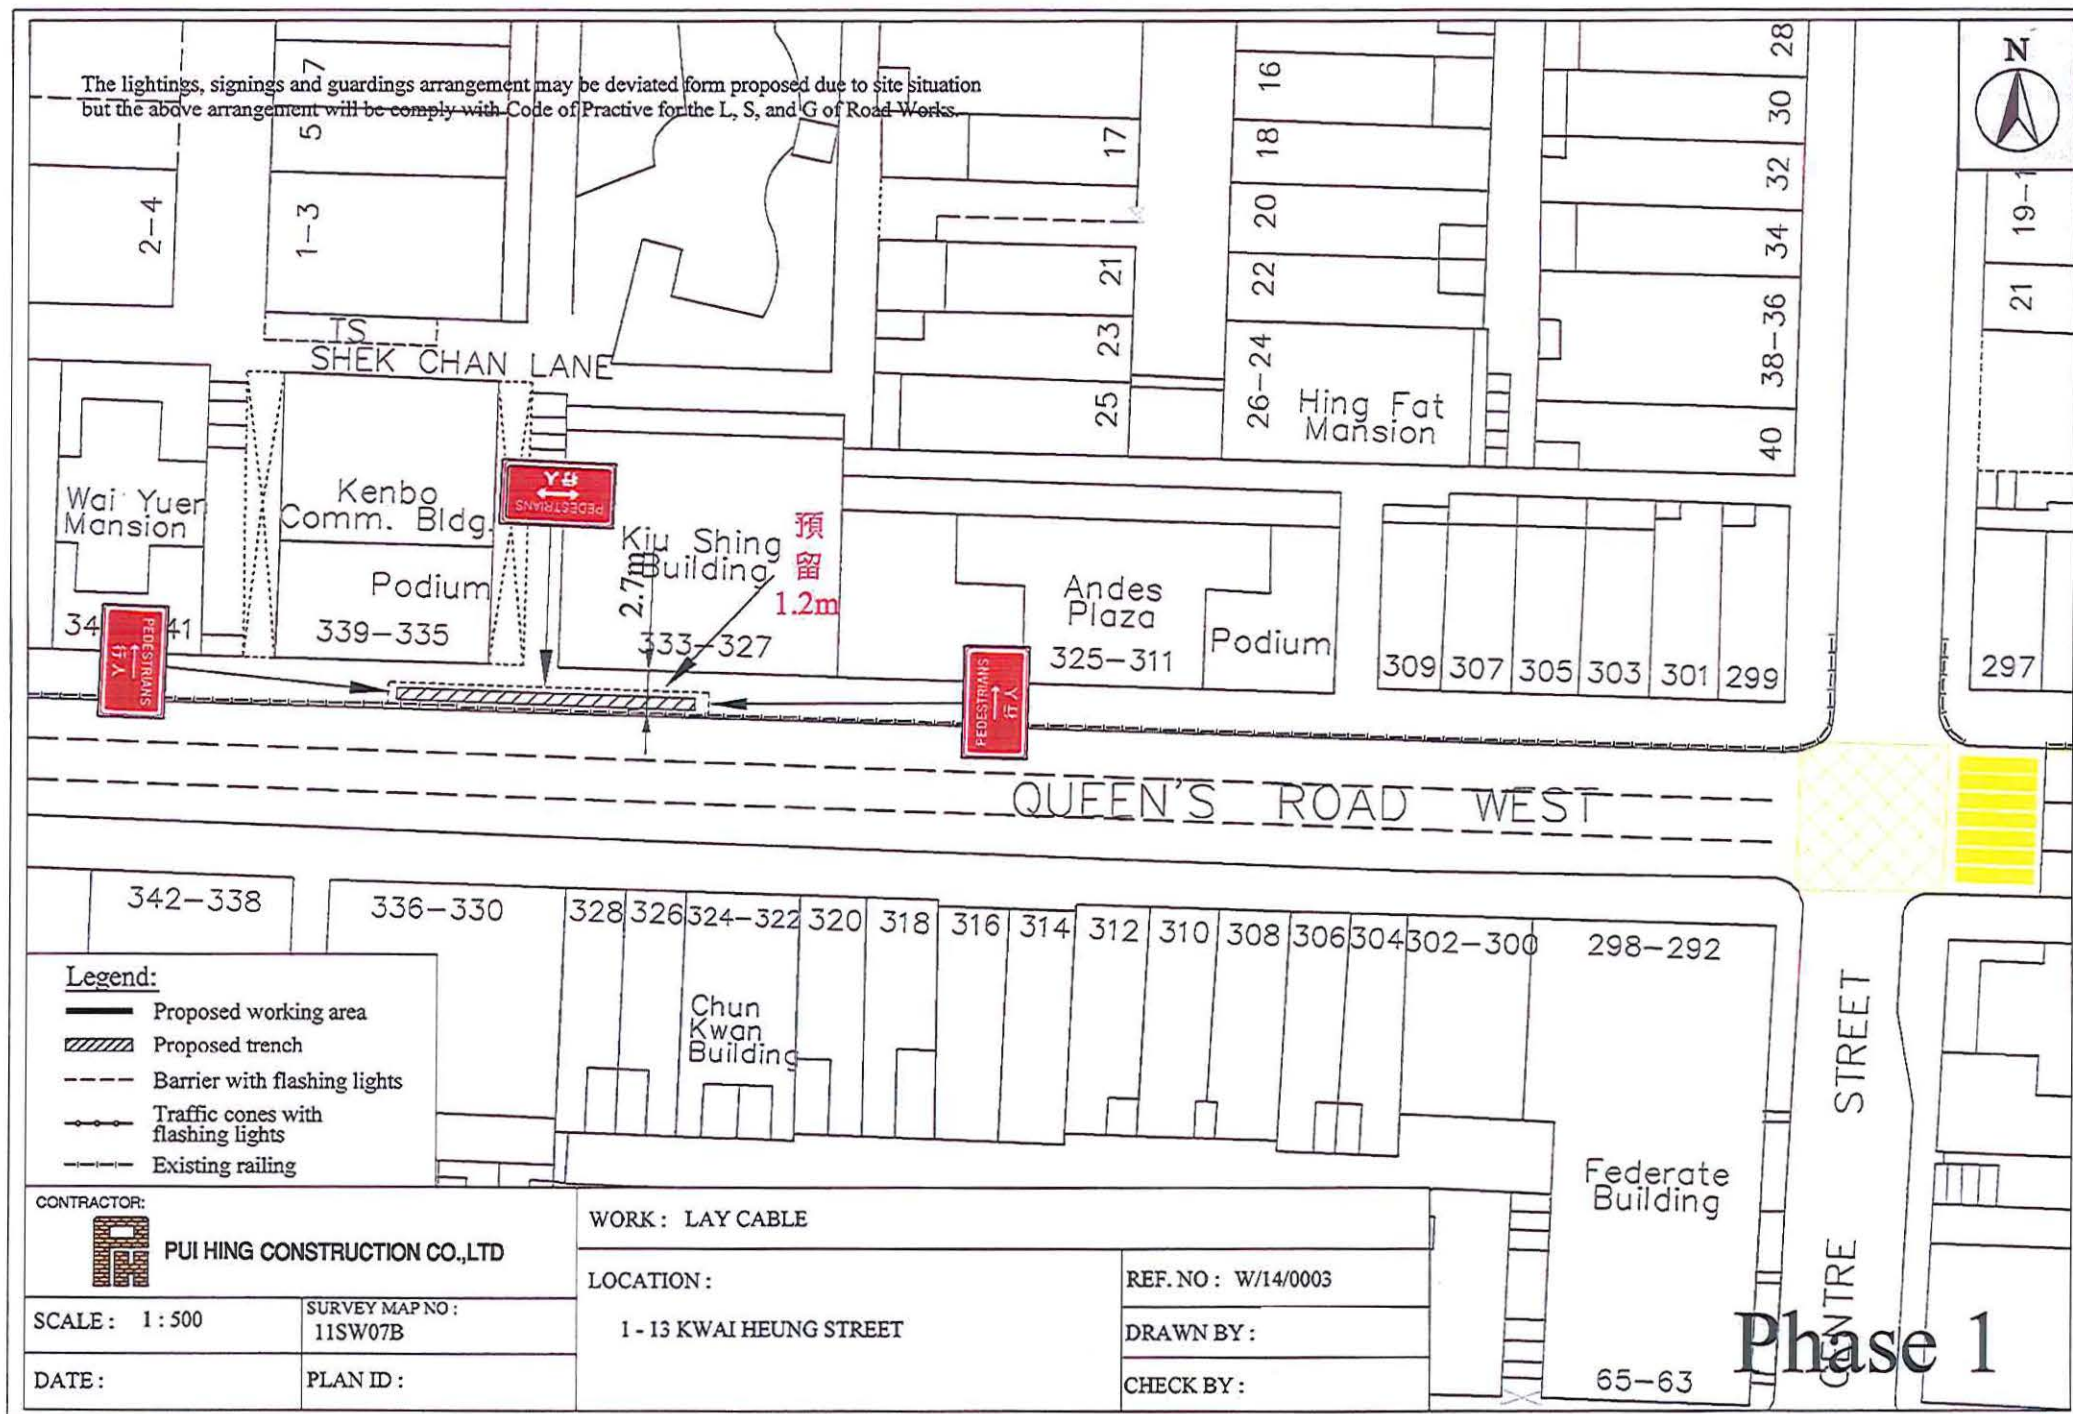

Legend:

- Proposed working area
- Proposed trench
- Barrier with flashing lights
- Traffic cones with flashing lights
- Existing railing

CONTRACTOR:



PUI HING CONSTRUCTION CO.,LTD

SCALE: 1 : 500

SURVEY MAP NO:
11SW07B

DATE:

PLAN ID:

WORK : LAY CABLE

LOCATION :

1 - 13 KWAI HEUNG STREET

REF. NO : W/14/0003

DRAWN BY :

CHECK BY :

Federate Building

65-63

Phase 1

The lightings, signings and guardings arrangement may be deviated from proposed due to site situation but the above arrangement will be comply with Code of Practice for the L, S, and G of Road Works.

SHEK CHAN LANE

Wai Yuer Mansion

Kenbo Comm. Bldg.

Podium

Kiu Shing Building

Andes Plaza

Podium

Hing Fat Mansion

Federate Building

Chun Kwan Building

QUEEN'S ROAD WEST

STREET



- Legend:**
- Proposed working area
 - Proposed trench
 - Barrier with flashing lights
 - Traffic cones with flashing lights
 - Existing railing

CONTRACTOR:

PUI HING CONSTRUCTION CO.,LTD


SCALE: 1:500
 SURVEY MAP NO: 11SW07B
 DATE:
 PLAN ID:

WORK: LAY CABLE
 LOCATION:
 1-13 KWAI HEUNG STREET


REF. NO: W/14/0003
 DRAWN BY:
 CHECK BY:

Phase 2

The lightings, signings and guardings arrangement may be deviated from proposed due to site situation but the above arrangement will comply with Code of Practice for the L, S, and G of Road Works.

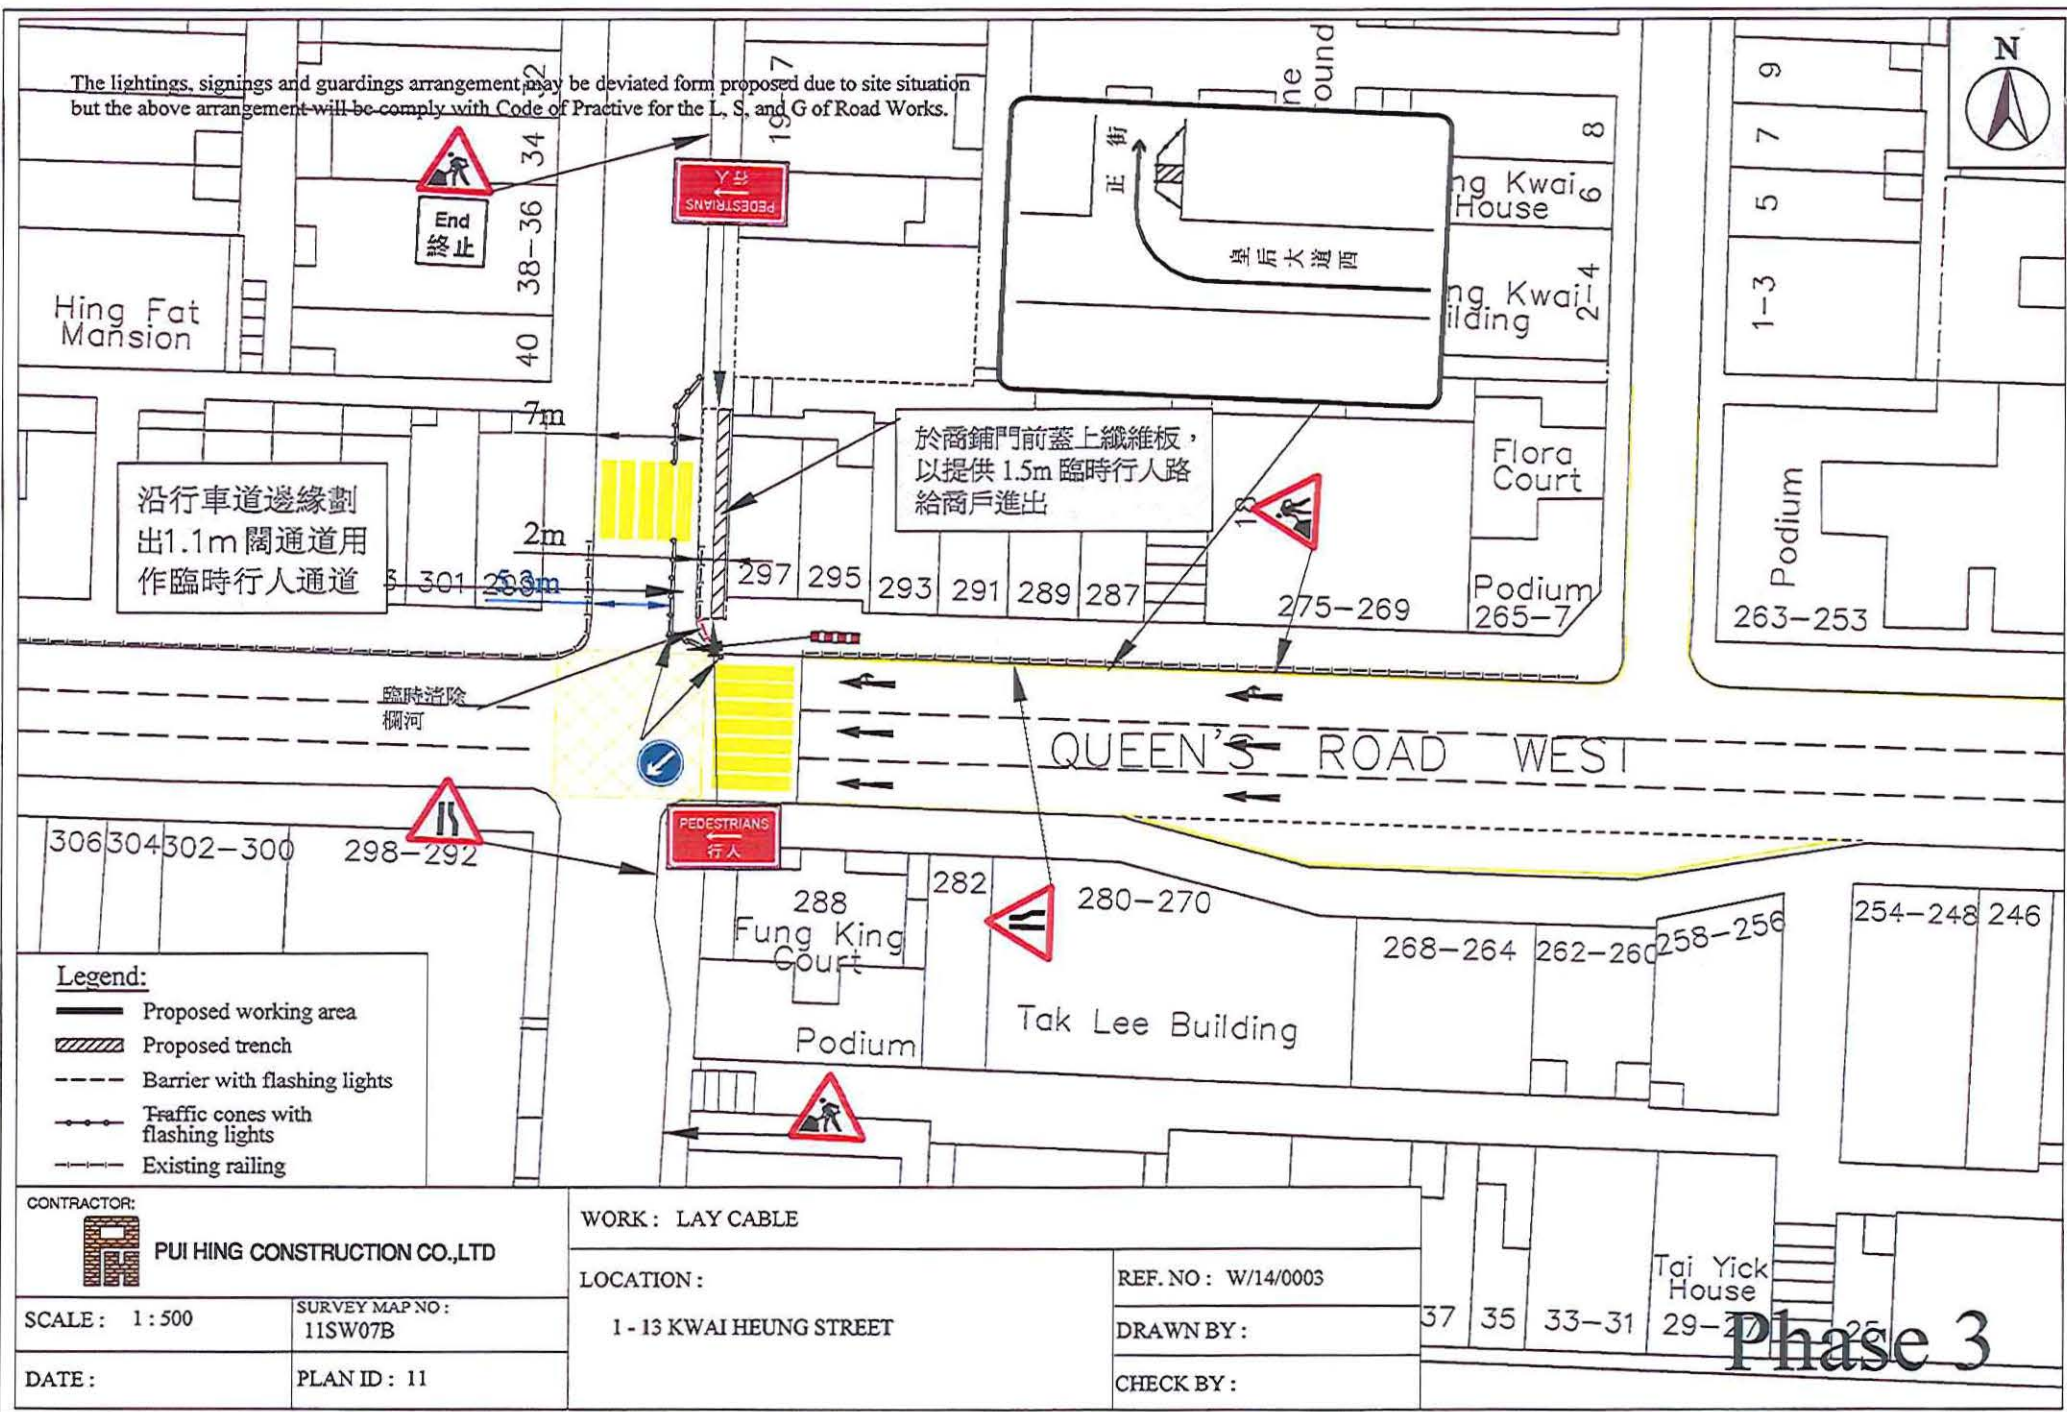

The lightings, signings and guardings arrangement may be deviated from proposed due to site situation but the above arrangement will be comply with Code of Practice for the L, S, and G of Road Works.

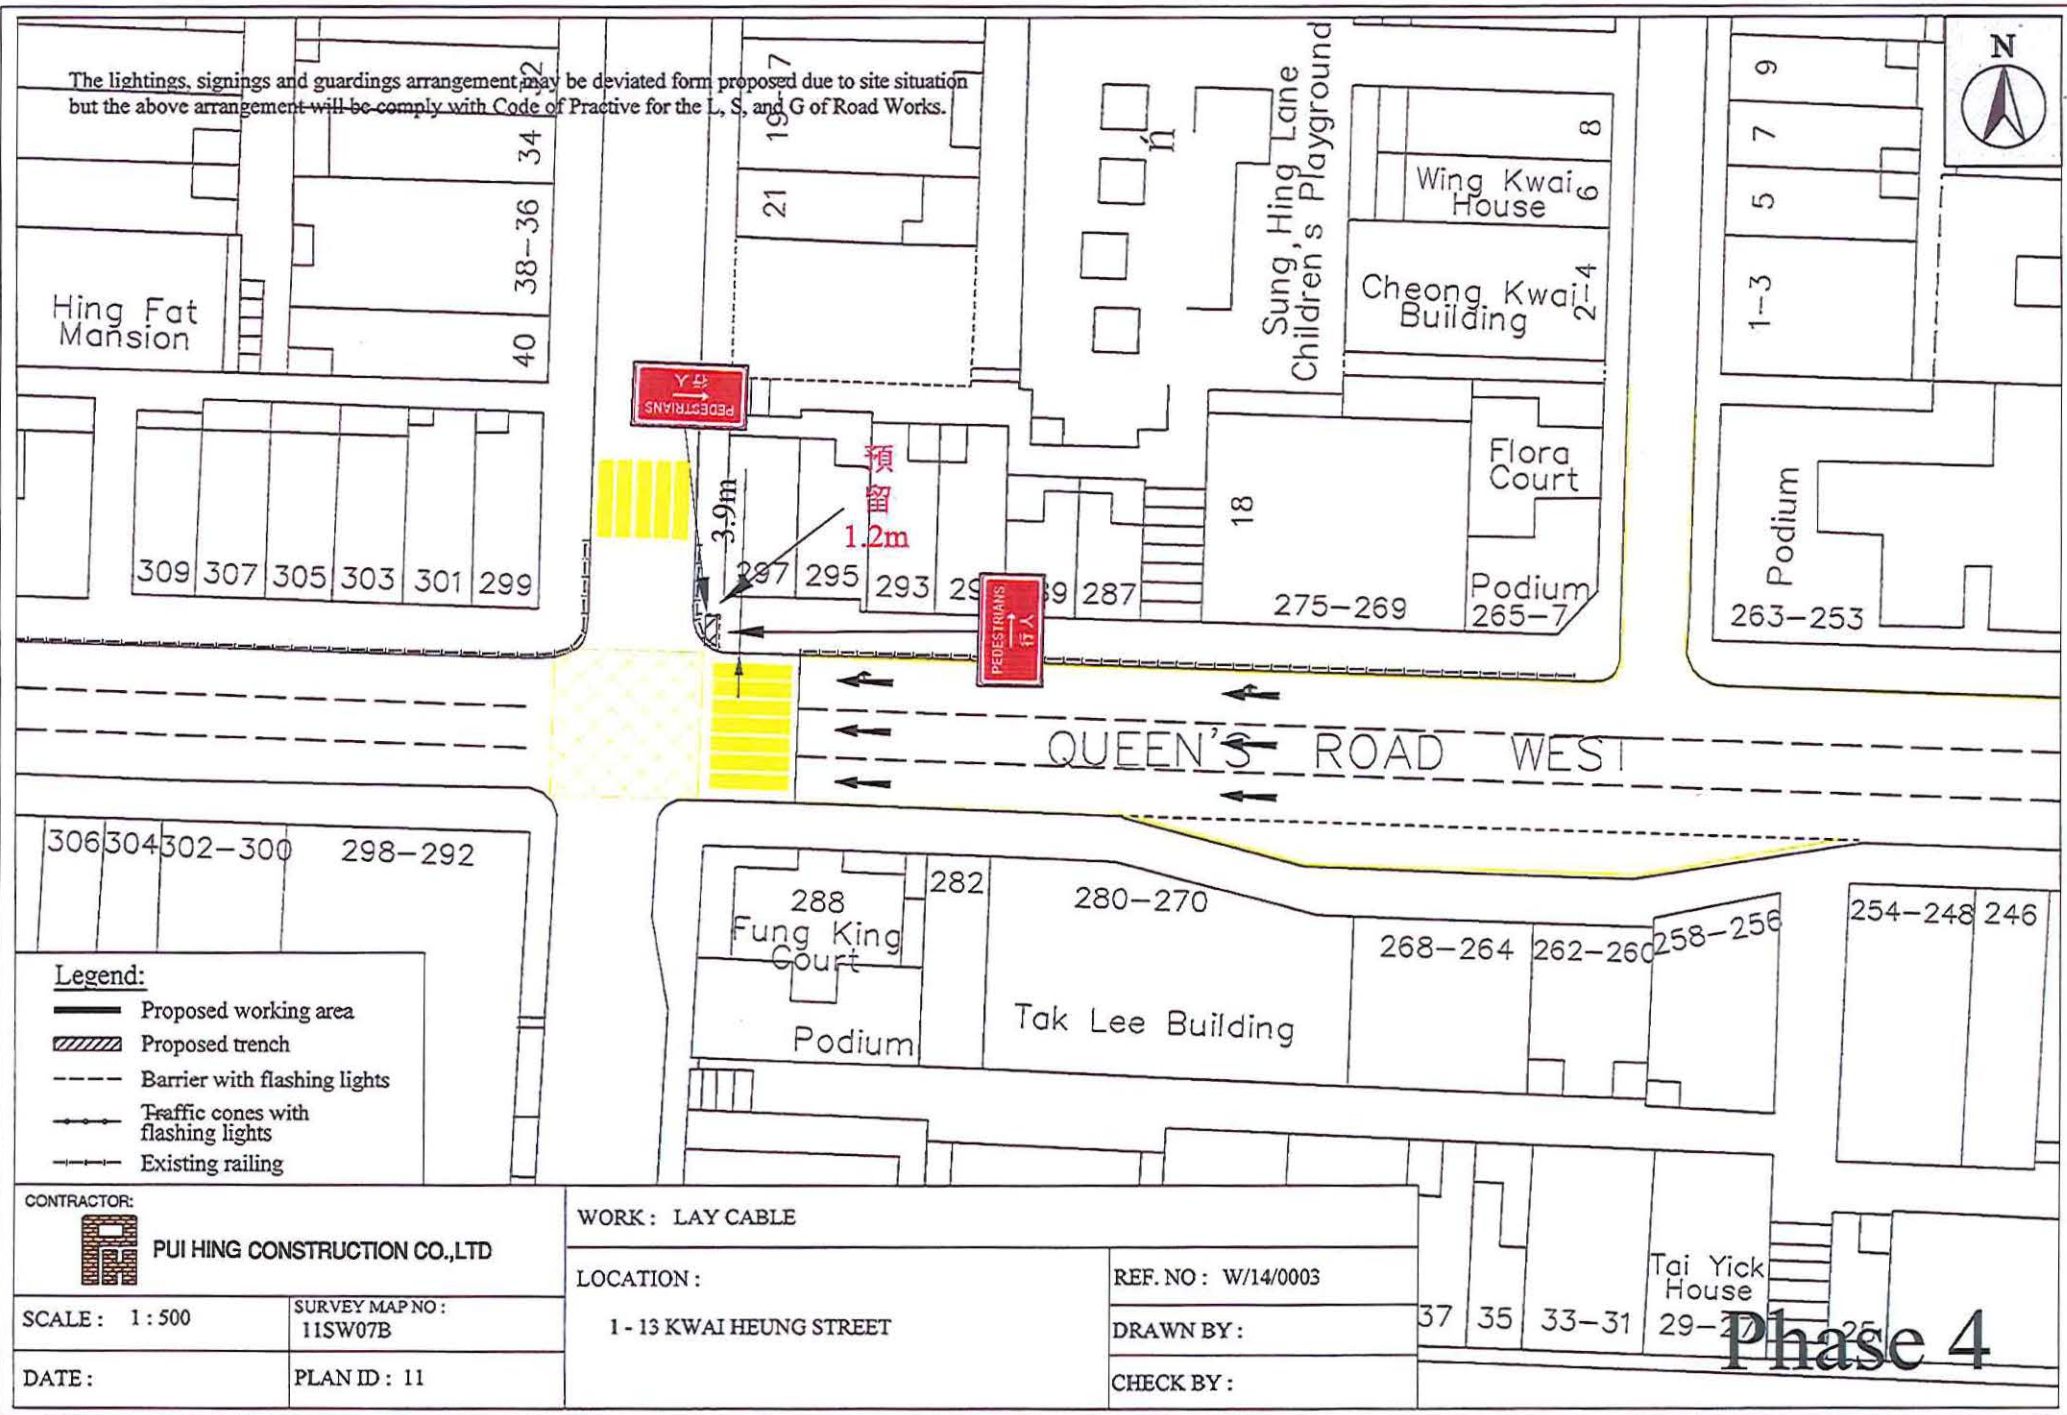

Legend:

- Proposed working area
- Proposed trench
- Barrier with flashing lights
- Traffic cones with flashing lights
- Existing railing

CONTRACTOR:



PUI HING CONSTRUCTION CO.,LTD

SCALE: 1:500

SURVEY MAP NO:
11SW07B

DATE:

PLAN ID: 11

WORK: LAY CABLE

LOCATION:

1 - 13 KWAI HEUNG STREET

REF. NO: W/14/0003

DRAWN BY:

CHECK BY:

Tai Yick House

Phase 4

The lightings, signings and guardings arrangement may be deviated from proposed due to site situation but the above arrangement will be comply with Code of Practice for the L, S, and G of Road Works.

於商舖門前蓋上纖維板，
以提供 1.5m 臨時行人路
給商戶進出

Hing Fat Mansion

Sung, Hing Lane
Children's Playground

Wing Kwai House

Cheong Kwai Building

Flora Court

Podium

Podium

263-253

309 307 305 303 301 299

297 295 293 291 289 287 275-269

QUEEN'S ROAD WEST

預留
1.2m

306 304 302-300 298-292

288 Fung King Court

282

280-270

Tak Lee Building

268-264

262-260

258-256

254-248 246

Legend:

- Proposed working area
- Proposed trench
- Barrier with flashing lights
- Traffic cones with flashing lights
- Existing railing

CONTRACTOR:



PUI HING CONSTRUCTION CO.,LTD

SCALE: 1:500

SURVEY MAP NO:
11SW07B

DATE:

PLAN ID: 11

WORK: LAY CABLE

LOCATION:

1-13 KWAI HEUNG STREET

REF. NO: W/14/0003

DRAWN BY:


CHECK BY:

Tai Yick House

Phase 5



The lightings, signings and guardings arrangement may be deviated from proposed due to site situation but the above arrangement will be comply with Code of Practice for the L, S, and G of Road Works.

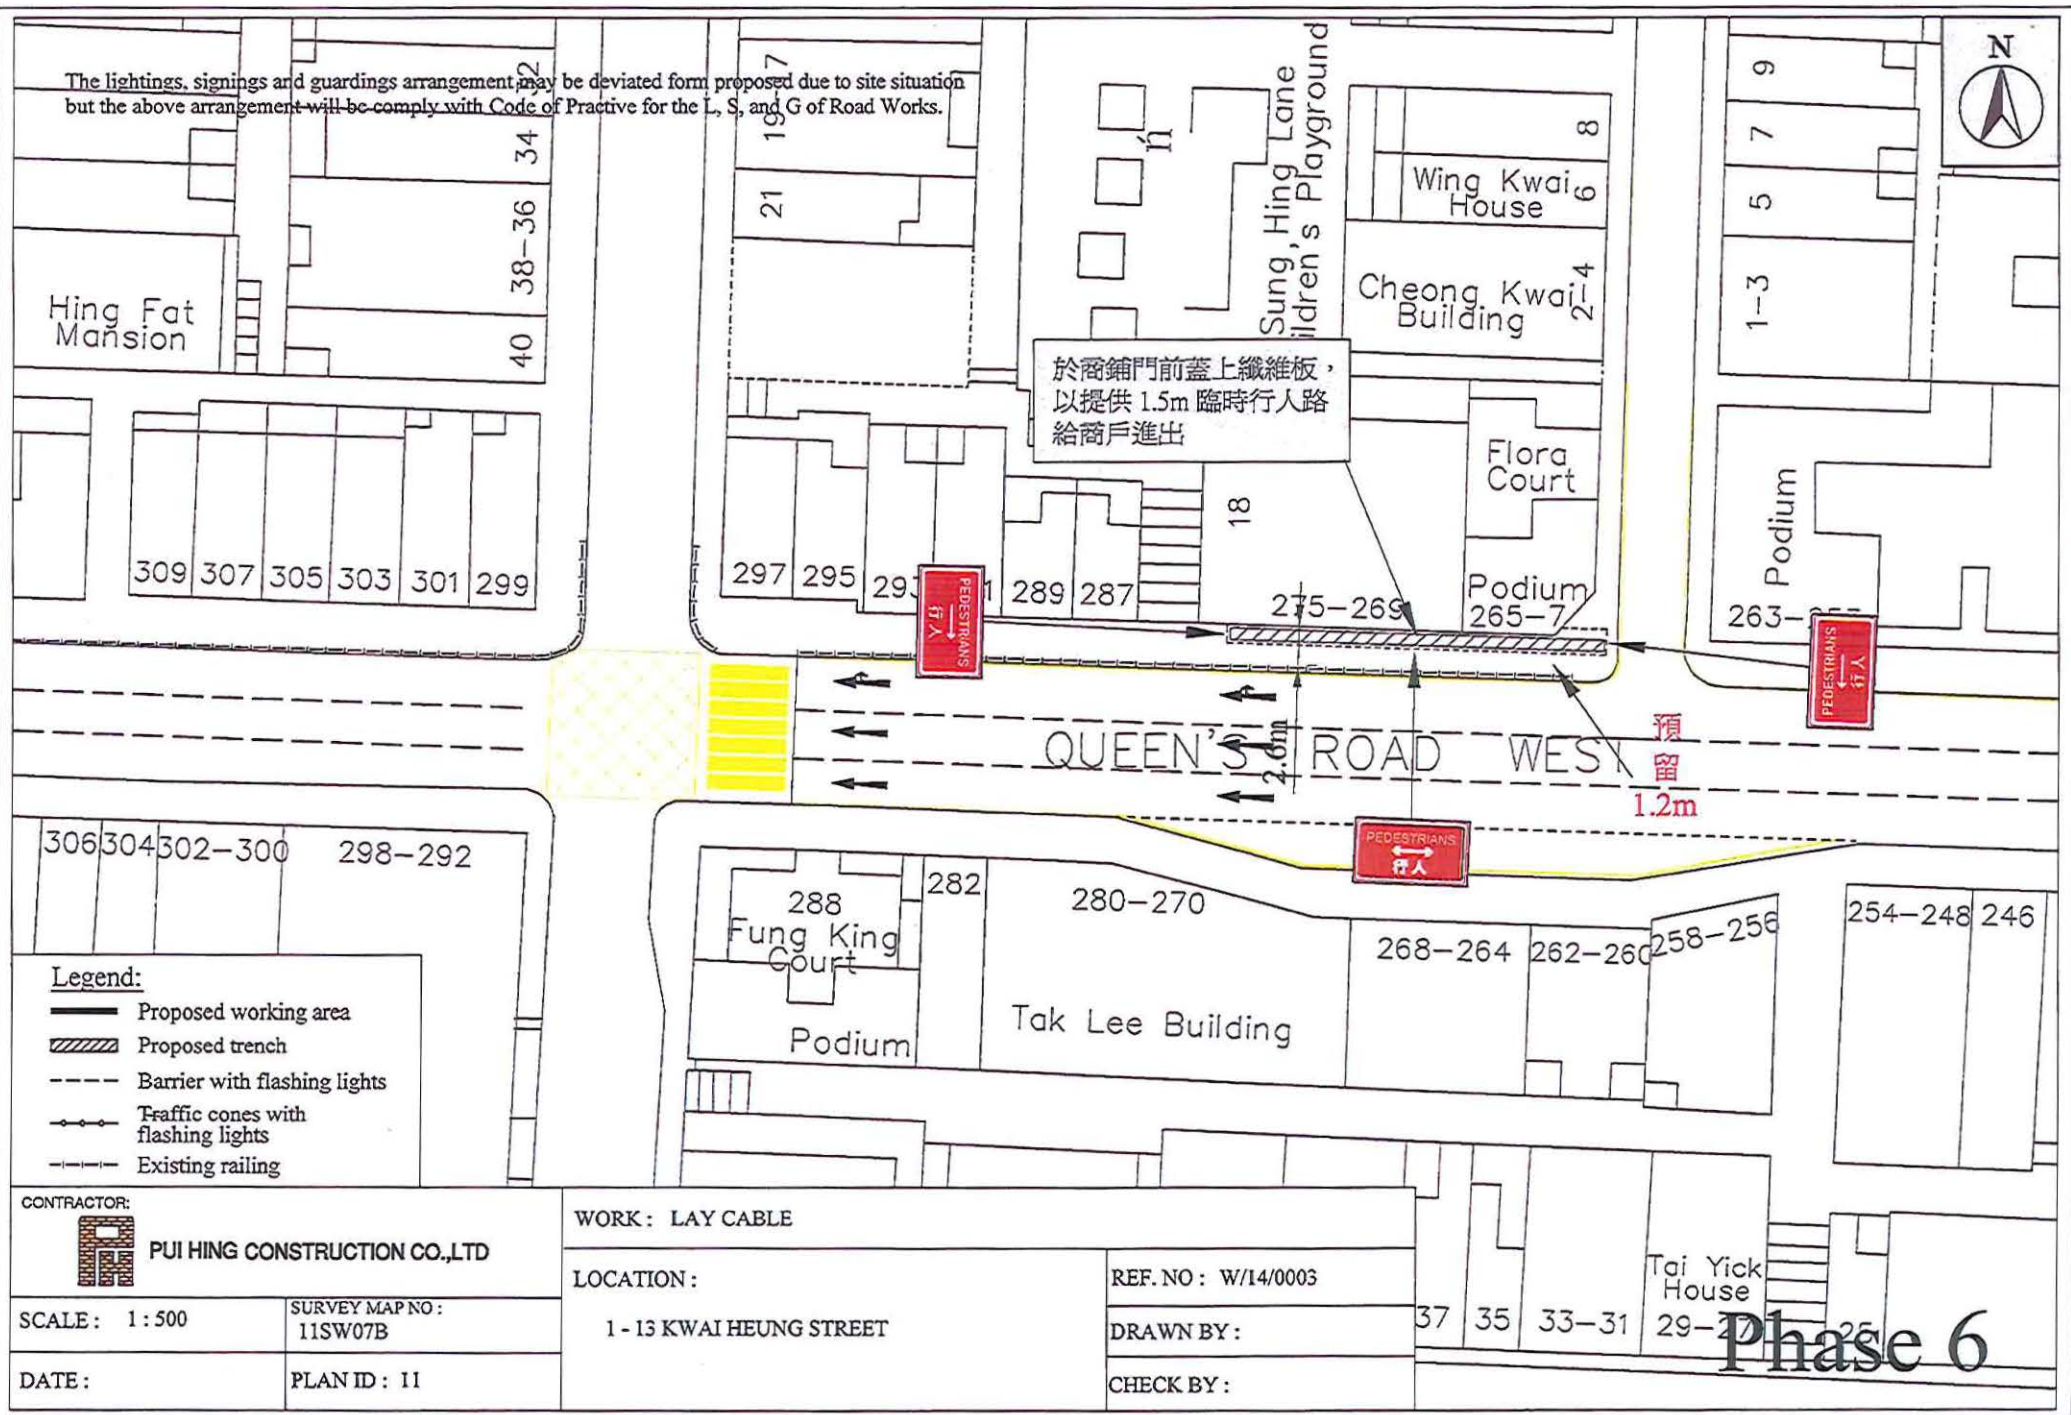

Legend:

- Proposed working area
- Proposed trench
- Barrier with flashing lights
- Traffic cones with flashing lights
- Existing railing

CONTRACTOR:



PUI HING CONSTRUCTION CO.,LTD

SCALE: 1:500

SURVEY MAP NO:
11SW07B

DATE:

PLAN ID: 11

WORK: LAY CABLE

LOCATION:

1-13 KWAI HEUNG STREET

REF. NO: W/14/0003

DRAWN BY:

CHECK BY:

Tai Yick House
29-31

Phase 6

The lightings, signings and guardings arrangement may be deviated from proposed due to site situation but the above arrangement will be comply with Code of Practice for the L, S, and G of Road Works.

Hing Fat Mansion

309 307 305 303 301 299

32
34
36
38-40

17
19
21

Sung, Hing Lane
Children's Playground

Wing Kwai House

Cheong Kwai Building

Flora Court

Podium 265-7

1-3
5
7
9

Podium

263-253

於商舖門前蓋上纖維板，
以提供 1.5m 臨時行人路
給商戶進出

18

297 295 293 291 289 287

275-269

1.6m

QUEEN'S ROAD WEST

306 304 302-300 298-292

288 Fung King Court

282

280-270

Tak Lee Building

Podium

268-264

262-260

258-256

254-248 246

Legend:

-  Proposed working area
-  Proposed trench
-  Barrier with flashing lights
-  Traffic cones with flashing lights
-  Existing railing

CONTRACTOR:



PUI HING CONSTRUCTION CO.,LTD

SCALE: 1:500

SURVEY MAP NO:
11SW07B

DATE:

PLAN ID: 11

WORK: LAY CABLE

LOCATION:

1-13 KWAI HEUNG STREET

REF. NO: W/14/0003

DRAWN BY:


CHECK BY:

Tai Yick House

Phase 7



The lightings, signings and guardings arrangement may be deviated from proposed due to site situation but the above arrangement will be comply with Code of Practice for the L, S, and G of Road Works.

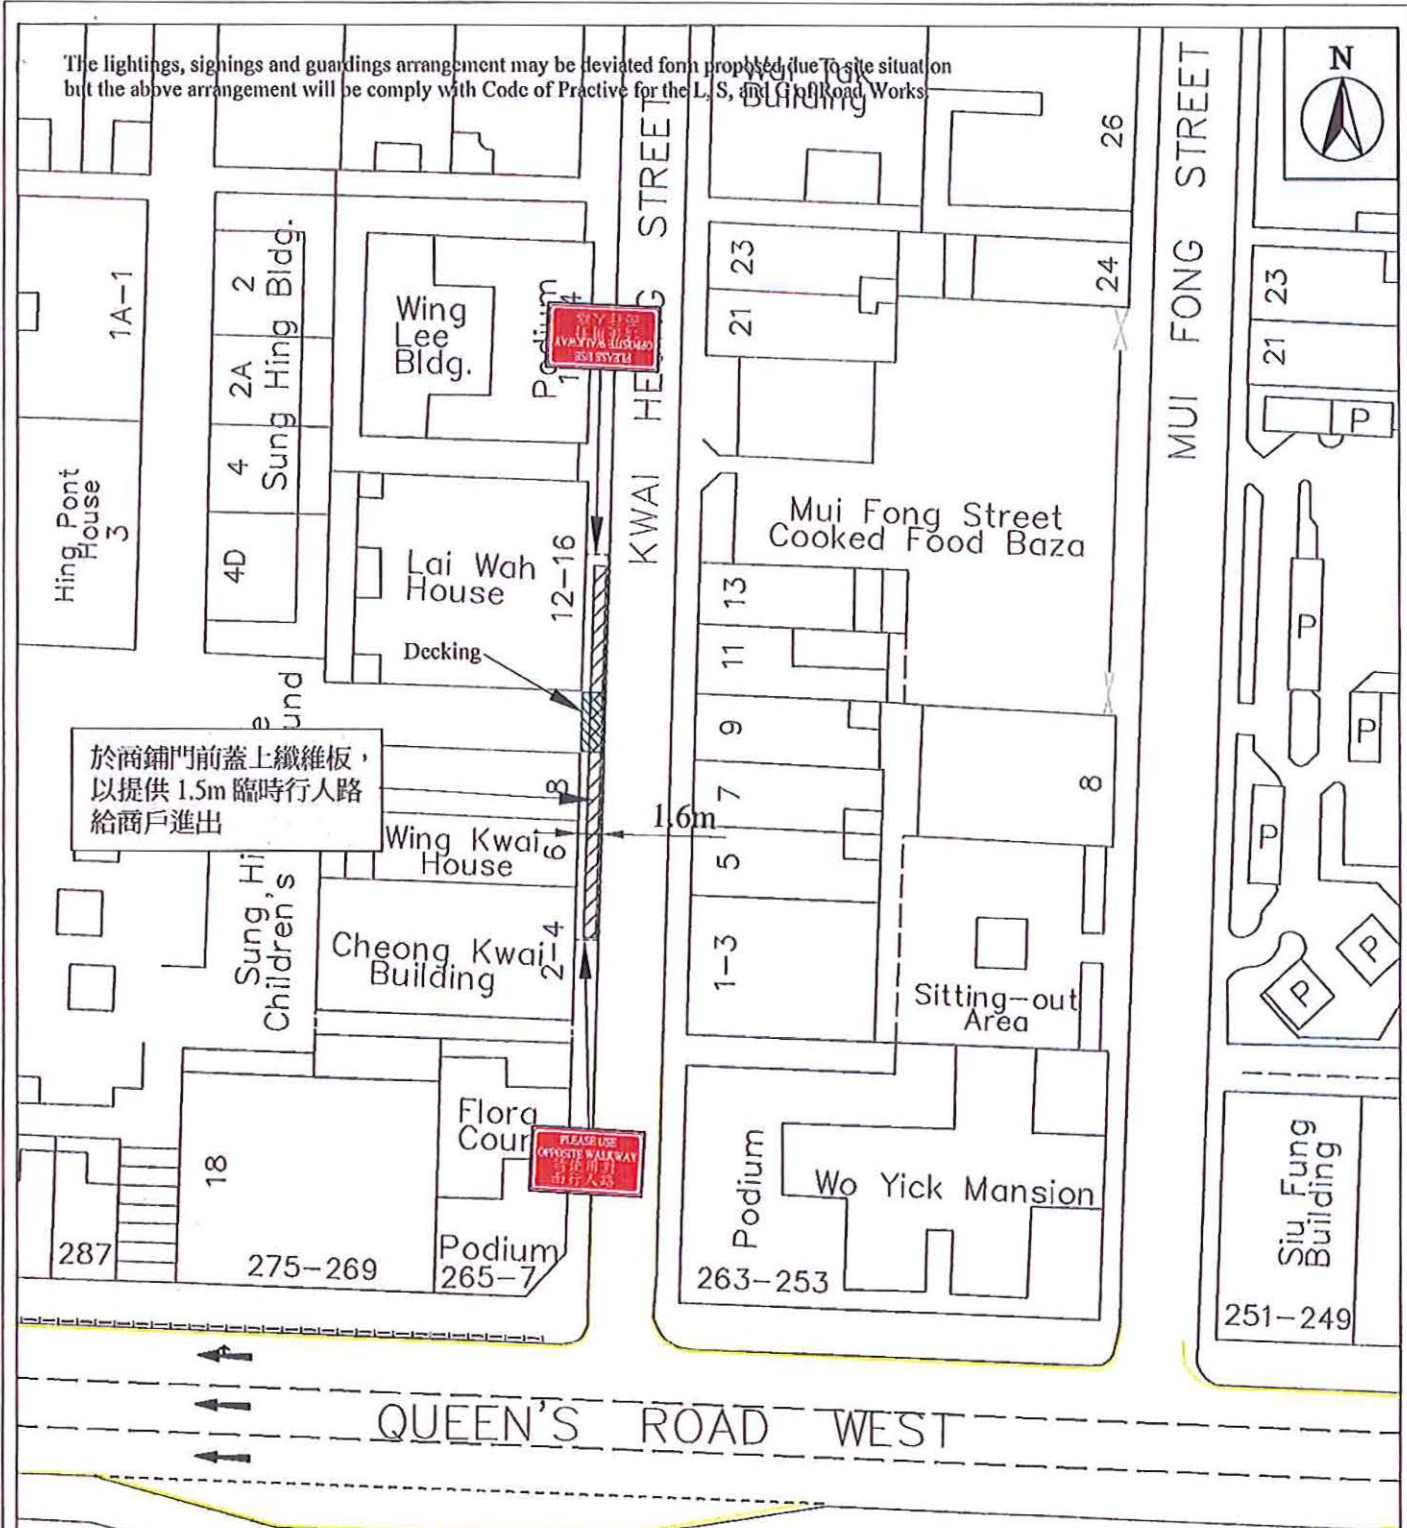

Phase 8

- Legend:**
- Proposed working area
 - Proposed trench
 - Barrier with flashing lights
 - Traffic cones with flashing lights
 - Existing railing

CONTRACTOR: PUI HING CONSTRUCTION CO.,LTD		WORK: LAY CABLE	
SCALE: 1:500	SURVEY MAP NO: 11SW07B	LOCATION: 1 - 13 KWAI HEUNG STREET	REF. NO: W/14/0003
DATE:	PLAN ID: 11		DRAWN BY:
			CHECK BY:

The lightings, signings and guardings arrangement may be deviated from proposed due to site situation but the above arrangement will be comply with Code of Practice for the L, S, and Traffic Road Works

1A-1
Hing Pont House 3
4
2A
Sung Hing Bldg.
4D
Wing Lee Bldg.
Podium 18-24
Lai Wah House 12-16
1.6m
Wing Kwai House 8
Cheong Kwai Building 2-4
Flora Court
Podium 265-7
275-269
287
18
Sung Hing Lane Children's Playground
8
Mui Fong Street Cooked Food
13
11
9
7
5
8
Sitting-out Area
Podium 263-253
Wo Yick Mansion
Siu Fung Building 251-249
240-238
244-242
246
254-248
258-256
262-260
268-264
280-270

Phase 9

CONTRACTOR: PUI HING CONSTRUCTION CO.,LTD

WORK: LAY CABLE

LOCATION: 1 - 13 KWAI HEUNG STREET

REF. NO : W/14/0003

DRAWN BY :

CHECK BY :

SCALE: 1 : 500

SURVEY MAP NO: 11SW07B

DATE:

PLAN ID: 11

Legend:

- Proposed working area
- Proposed trench
- Barrier with flashing lights
- Traffic cones with flashing lights
- Existing railing

於商舖門前蓋上纖維板，以提供 1.5m 臨時行人路給商戶進出

Phase 9

CONTRACTOR:



PUI HING CONSTRUCTION CO.,LTD

SCALE : 1 : 500

SURVEY MAP NO:
11SW07B

DATE :

PLAN ID: 11

WORK: LAY CABLE

LOCATION :


1 - 13 KWAI HEUNG STREET

REF. NO : W/14/0003

DRAWN BY :

CHECK BY :

The lightings, signings and guardings arrangement may be deviated from proposed due to site situation but the above arrangement will be comply with Code of Practice for the L, S, and G of Road Works

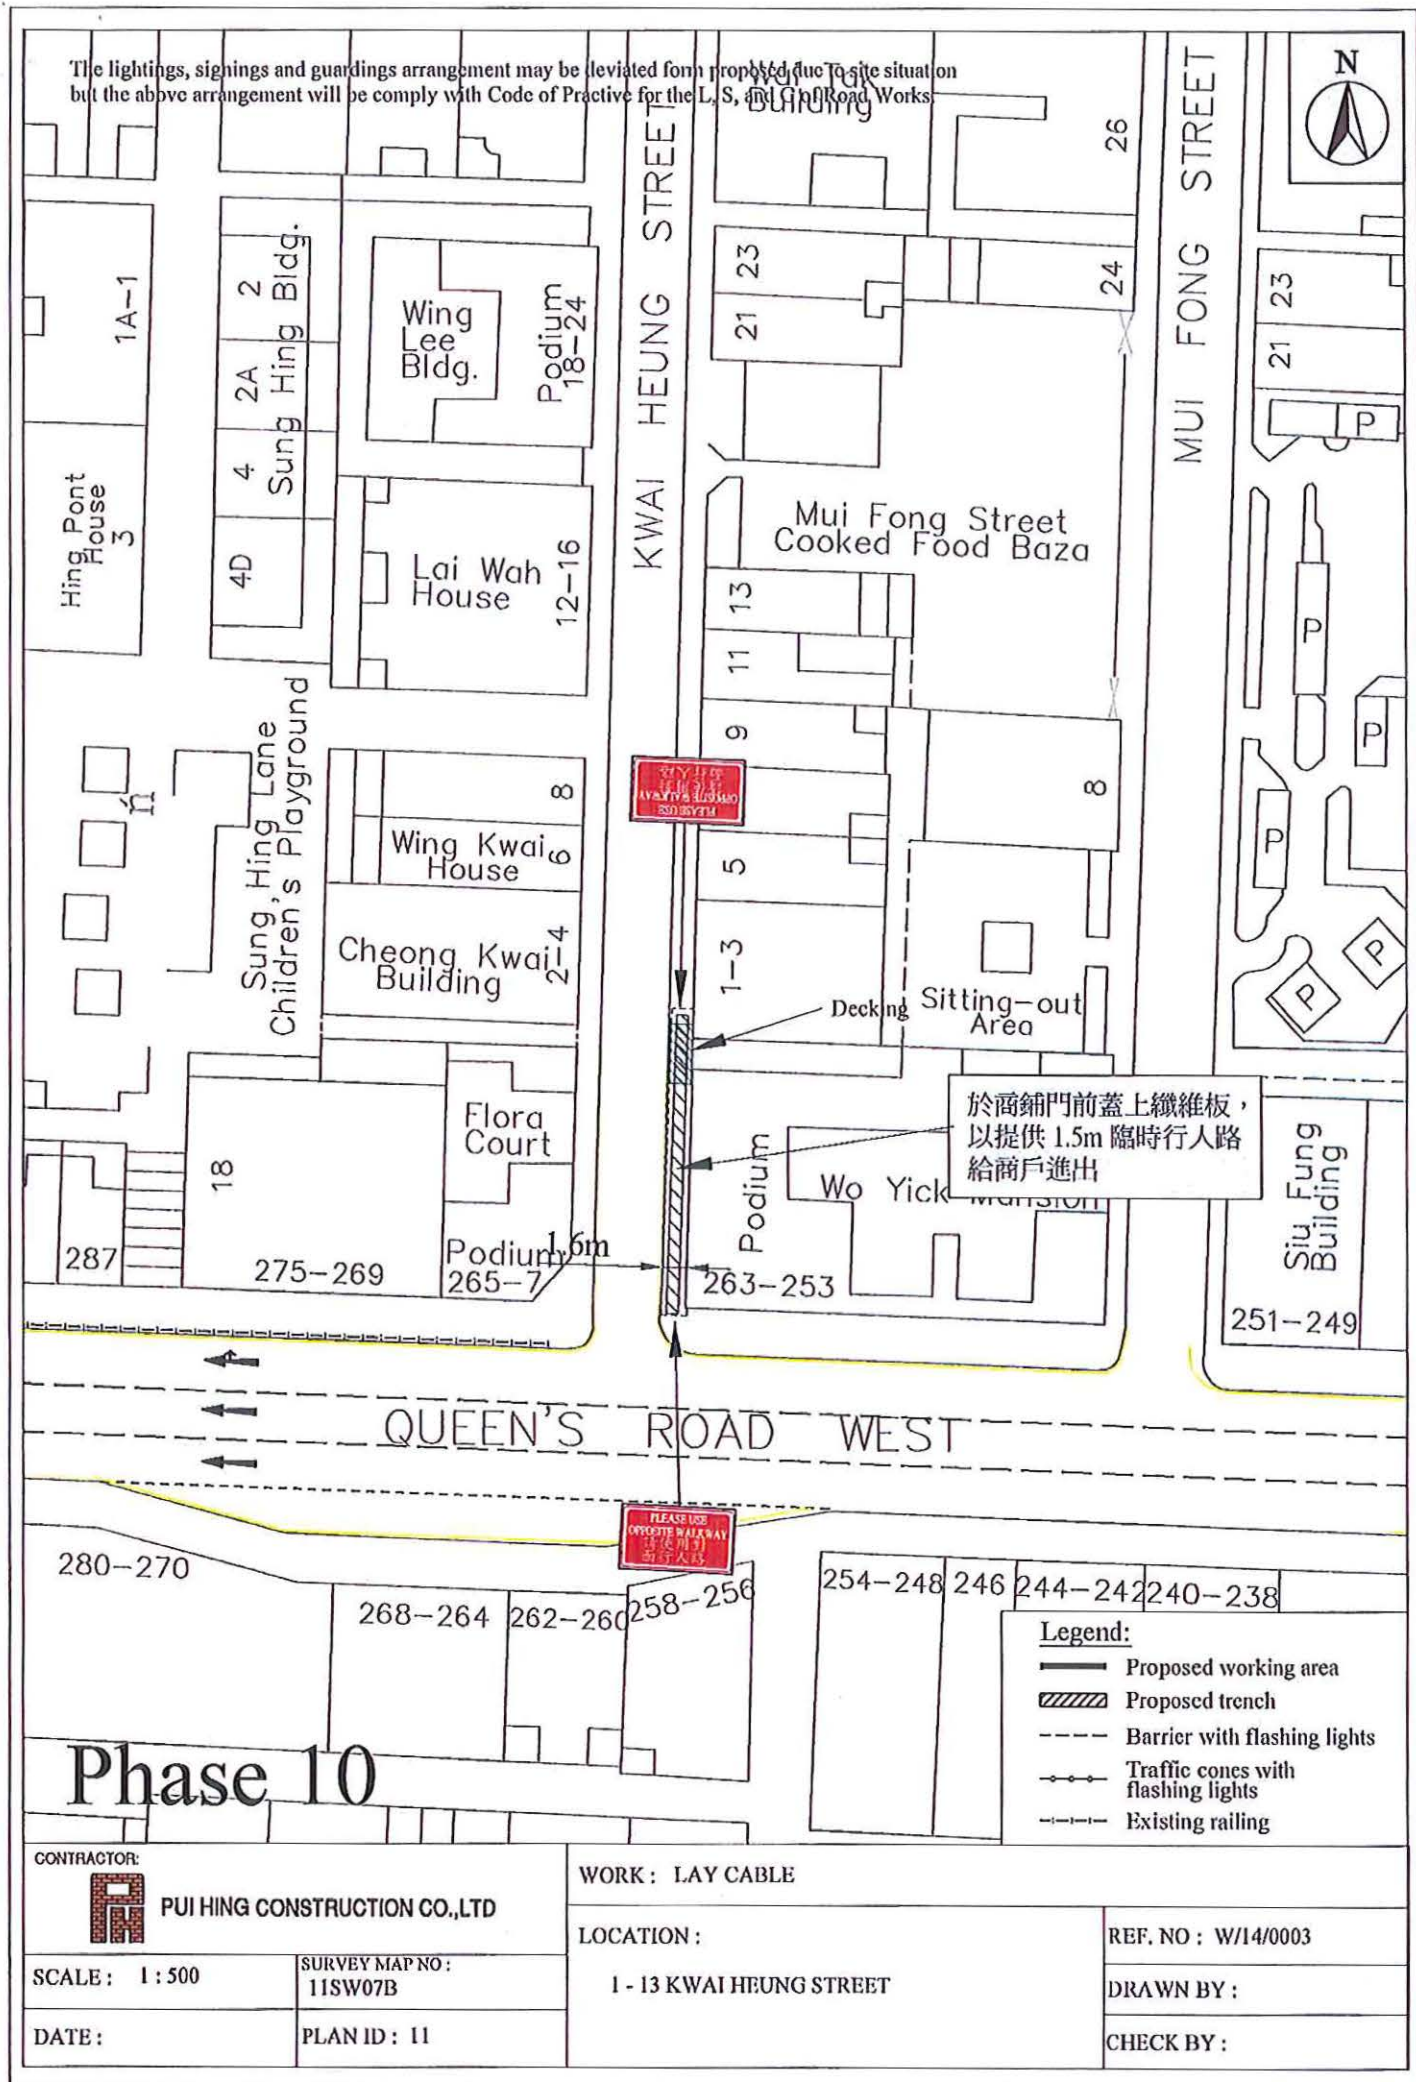

The lightings, signings and guardings arrangement may be deviated from proposed due to site situation but the above arrangement will be comply with Code of Practice for the L, S, and G of Road Works.

Phase 11

CONTRACTOR: PUI HING CONSTRUCTION CO., LTD

WORK: LAY CABLE

LOCATION: 1 - 13 KWAI HEUNG STREET

REF. NO: W/14/0003

SCALE: 1 : 500

SURVEY MAP NO: 11SW07B

DRAWN BY:

DATE:

PLAN ID: 11


CHECK BY:

Legend:

- Proposed working area
- Proposed trench
- Barrier with flashing lights
- Traffic cones with flashing lights
- Existing railing

CONTRACTOR:  PUI HING CONSTRUCTION CO.,LTD		WORK : LAY CABLE	
SCALE : 1 : 500		LOCATION : 1 - 13 KWAI HEUNG STREET	REF. NO : W/14/0003
SURVEY MAP NO : 11SW07B			DRAWN BY :
DATE :			CHECK BY :
PLAN ID : 11			

The lightings, signings and guardings arrangement may be deviated from proposed due to site situation but the above arrangement will be comply with Code of Practice for the L, S, and G of Road Works.

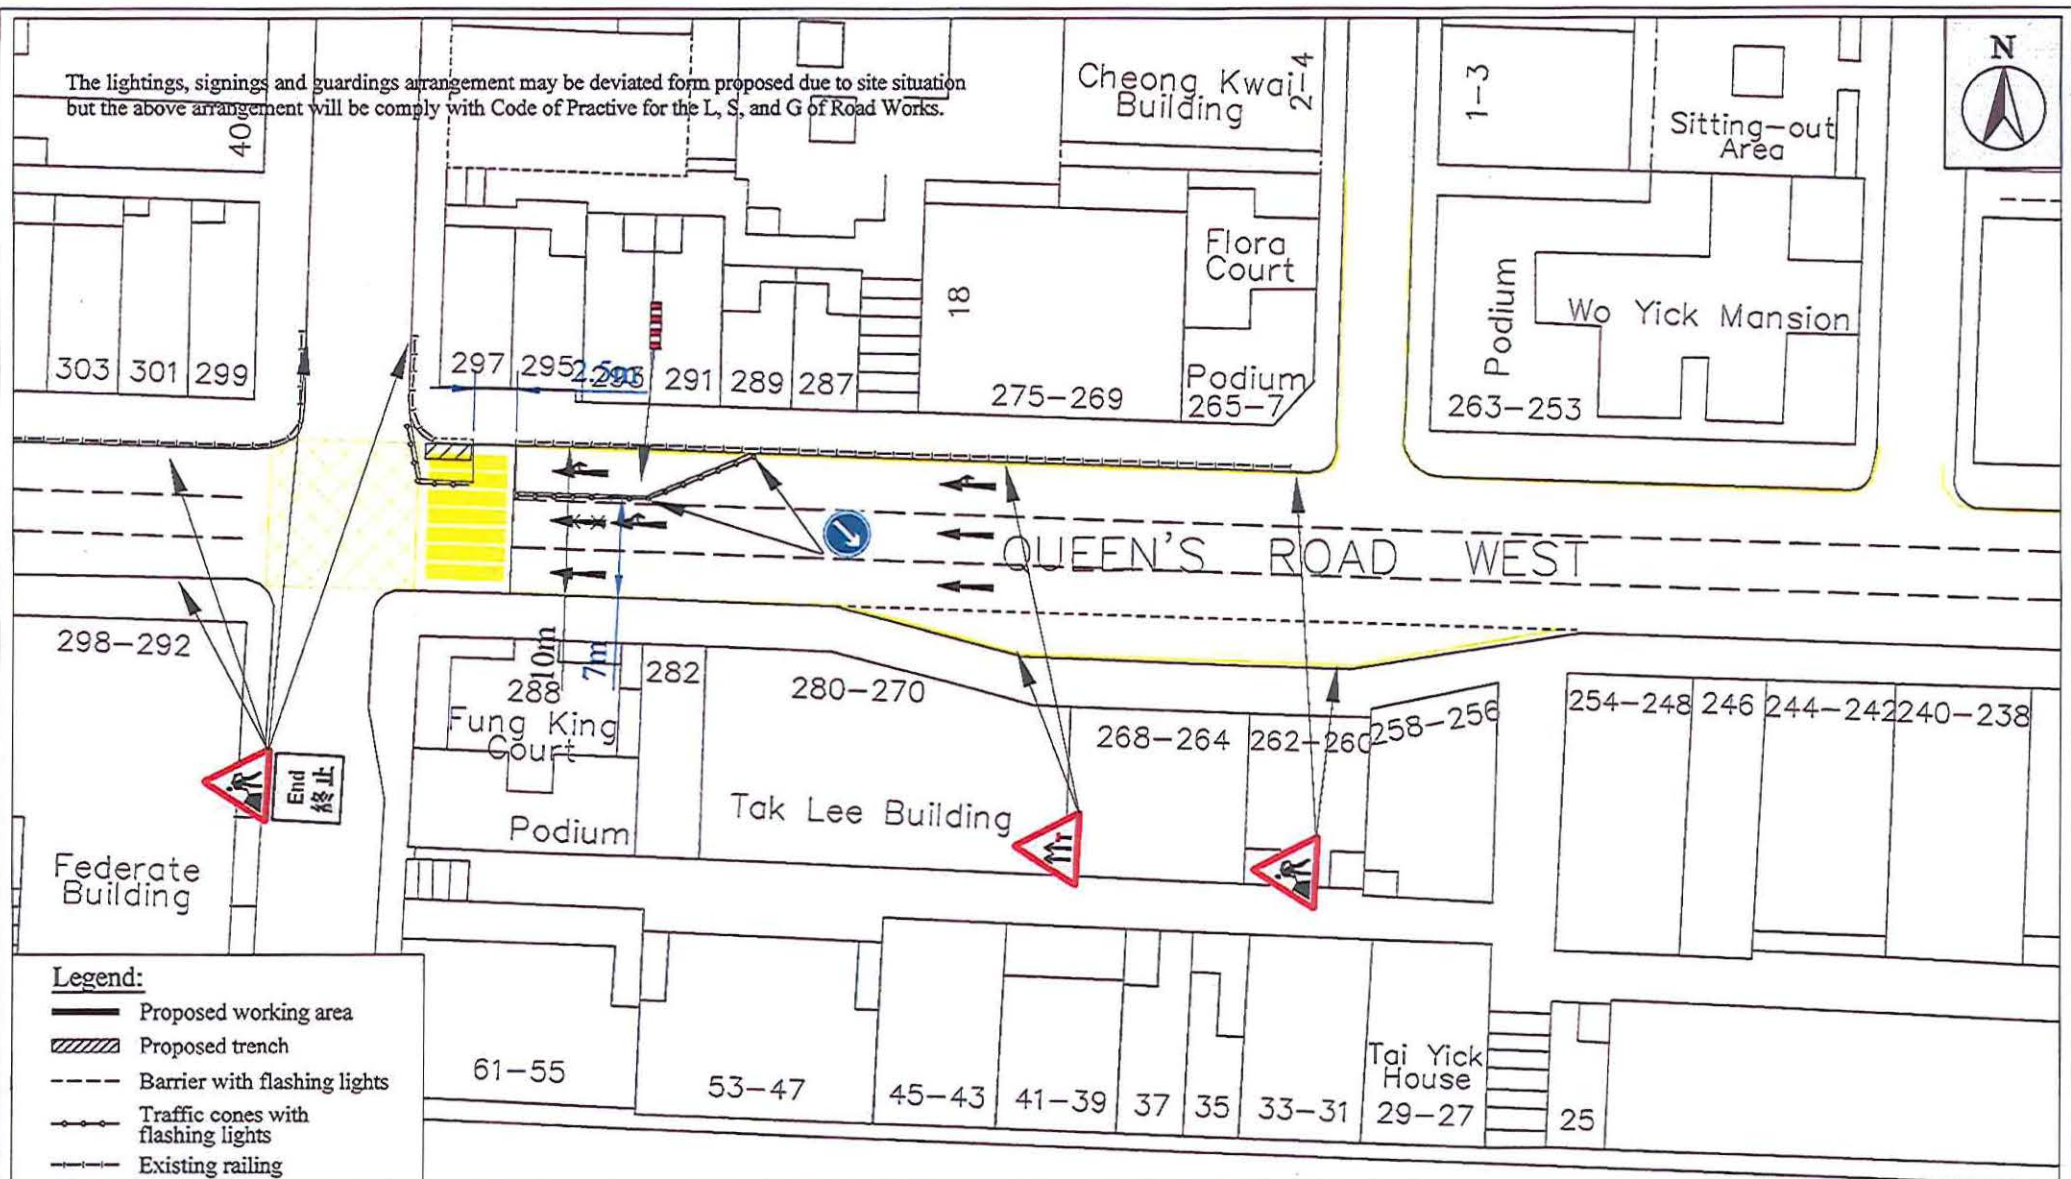

Legend:

- Proposed working area
- Proposed trench
- Barrier with flashing lights
- Traffic cones with flashing lights
- Existing railing

CONTRACTOR:



PUI HING CONSTRUCTION CO., LTD

WORK: LAY CABLE

LOCATION:

1-13 KWAI HEUNG STREET

REF. NO: W/14/0003

DRAWN BY:

CHECK BY:

SCALE: 1:500

SURVEY MAP NO:
11SW07B


DATE:

PLAN ID: 11

30 28 26 24 22 20 18 16 14 12

Phase 12

The lightings, signings and guardings arrangement may be deviated from proposed due to site situation but the above arrangement will be comply with Code of Practice for the L, S, and G of Road Works.

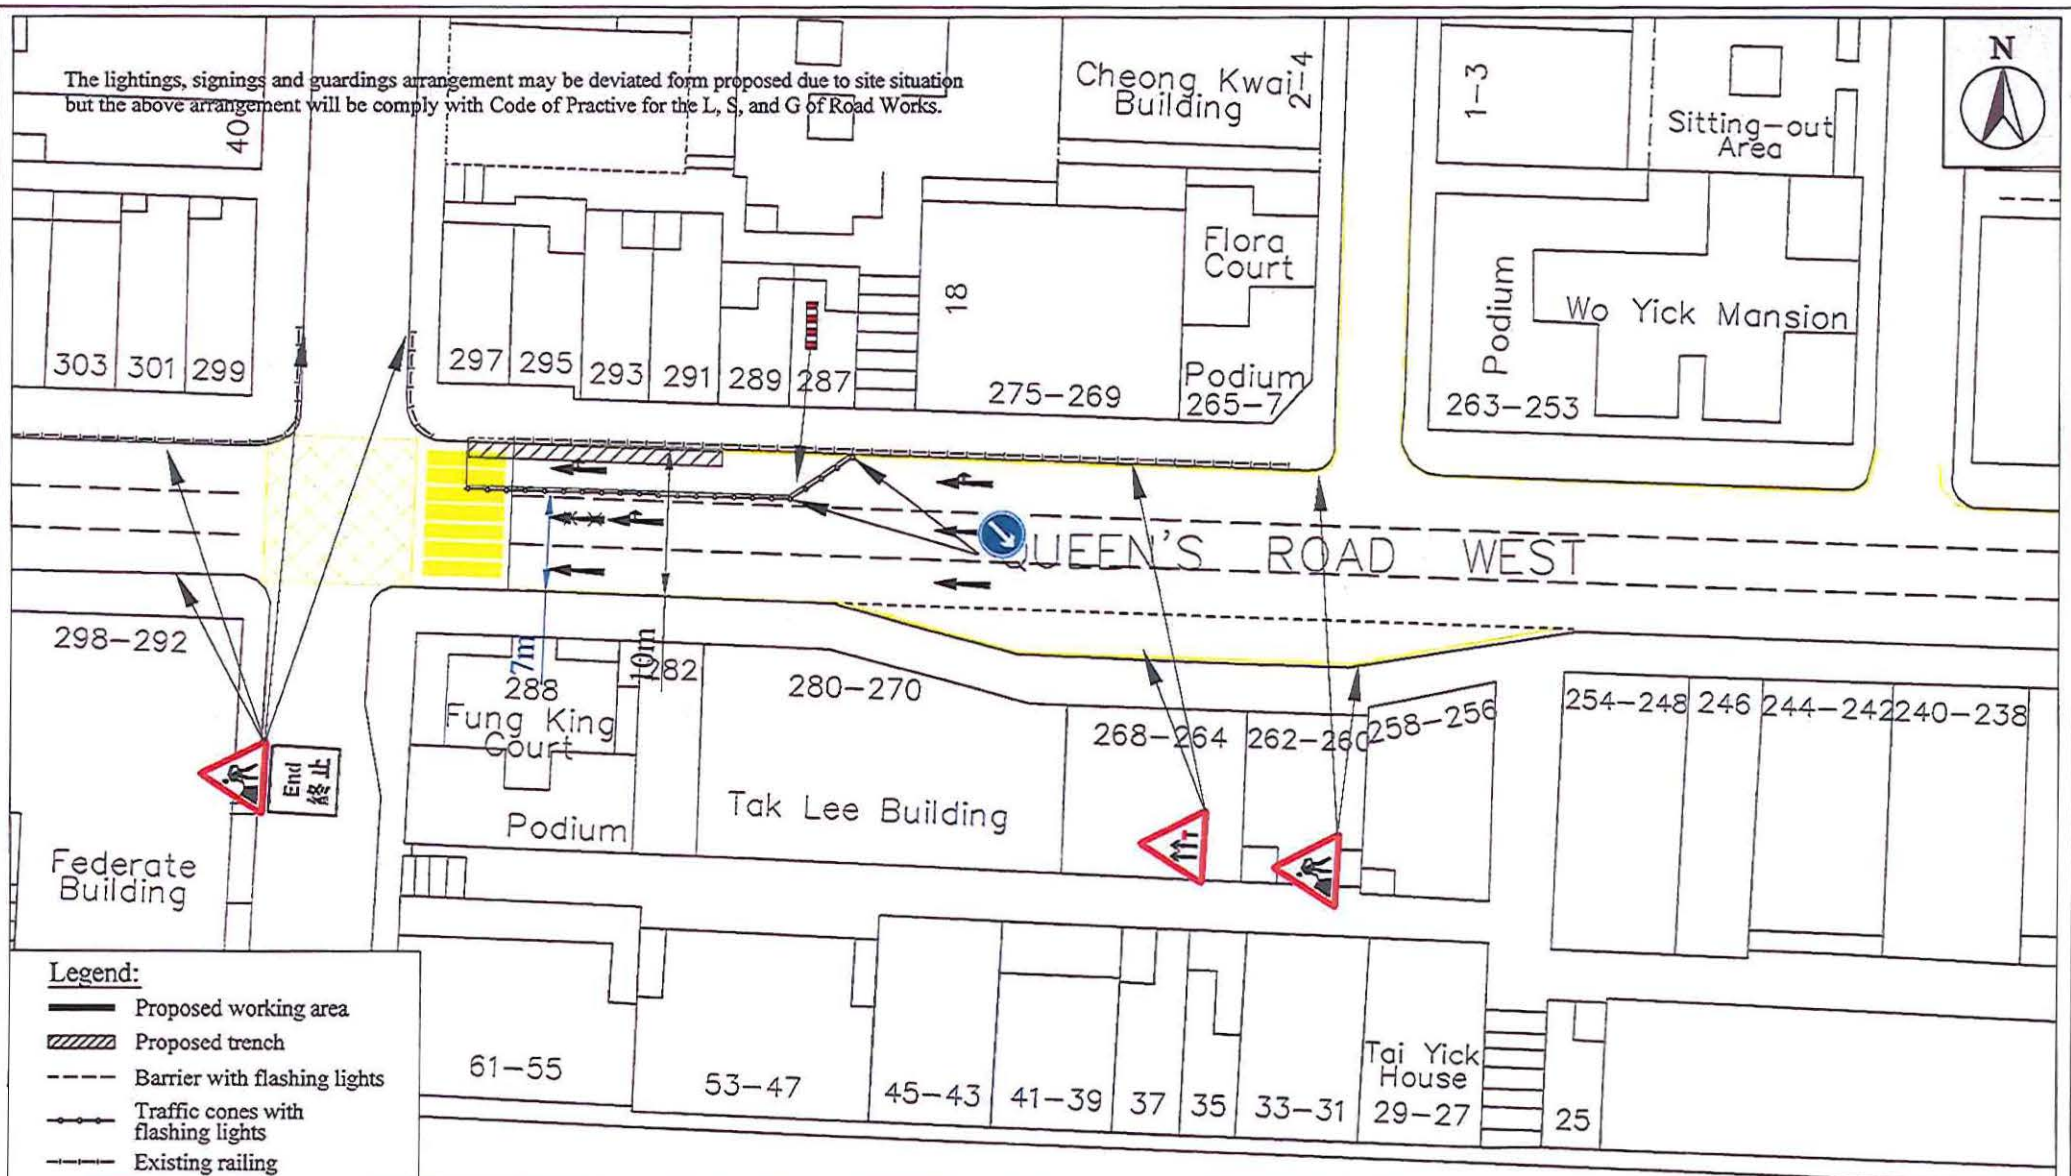

Legend:

- Proposed working area
- Proposed trench
- Barrier with flashing lights
- Traffic cones with flashing lights
- Existing railing

CONTRACTOR:



PUI HING CONSTRUCTION CO.,LTD

SCALE: 1 : 500

SURVEY MAP NO:
11SW07B

DATE:

PLAN ID : 11

WORK : LAY CABLE

LOCATION :

1 - 13 KWAI HEUNG STREET

REF. NO : W/14/0003


DRAWN BY :

CHECK BY :

30 28 26 24 22 20 18 16 14 12

Phase 13

The lightings, signings and guardings arrangement may be deviated from proposed due to site situation but the above arrangement will be comply with Code of Practice for the L, S, and G of Road Works.

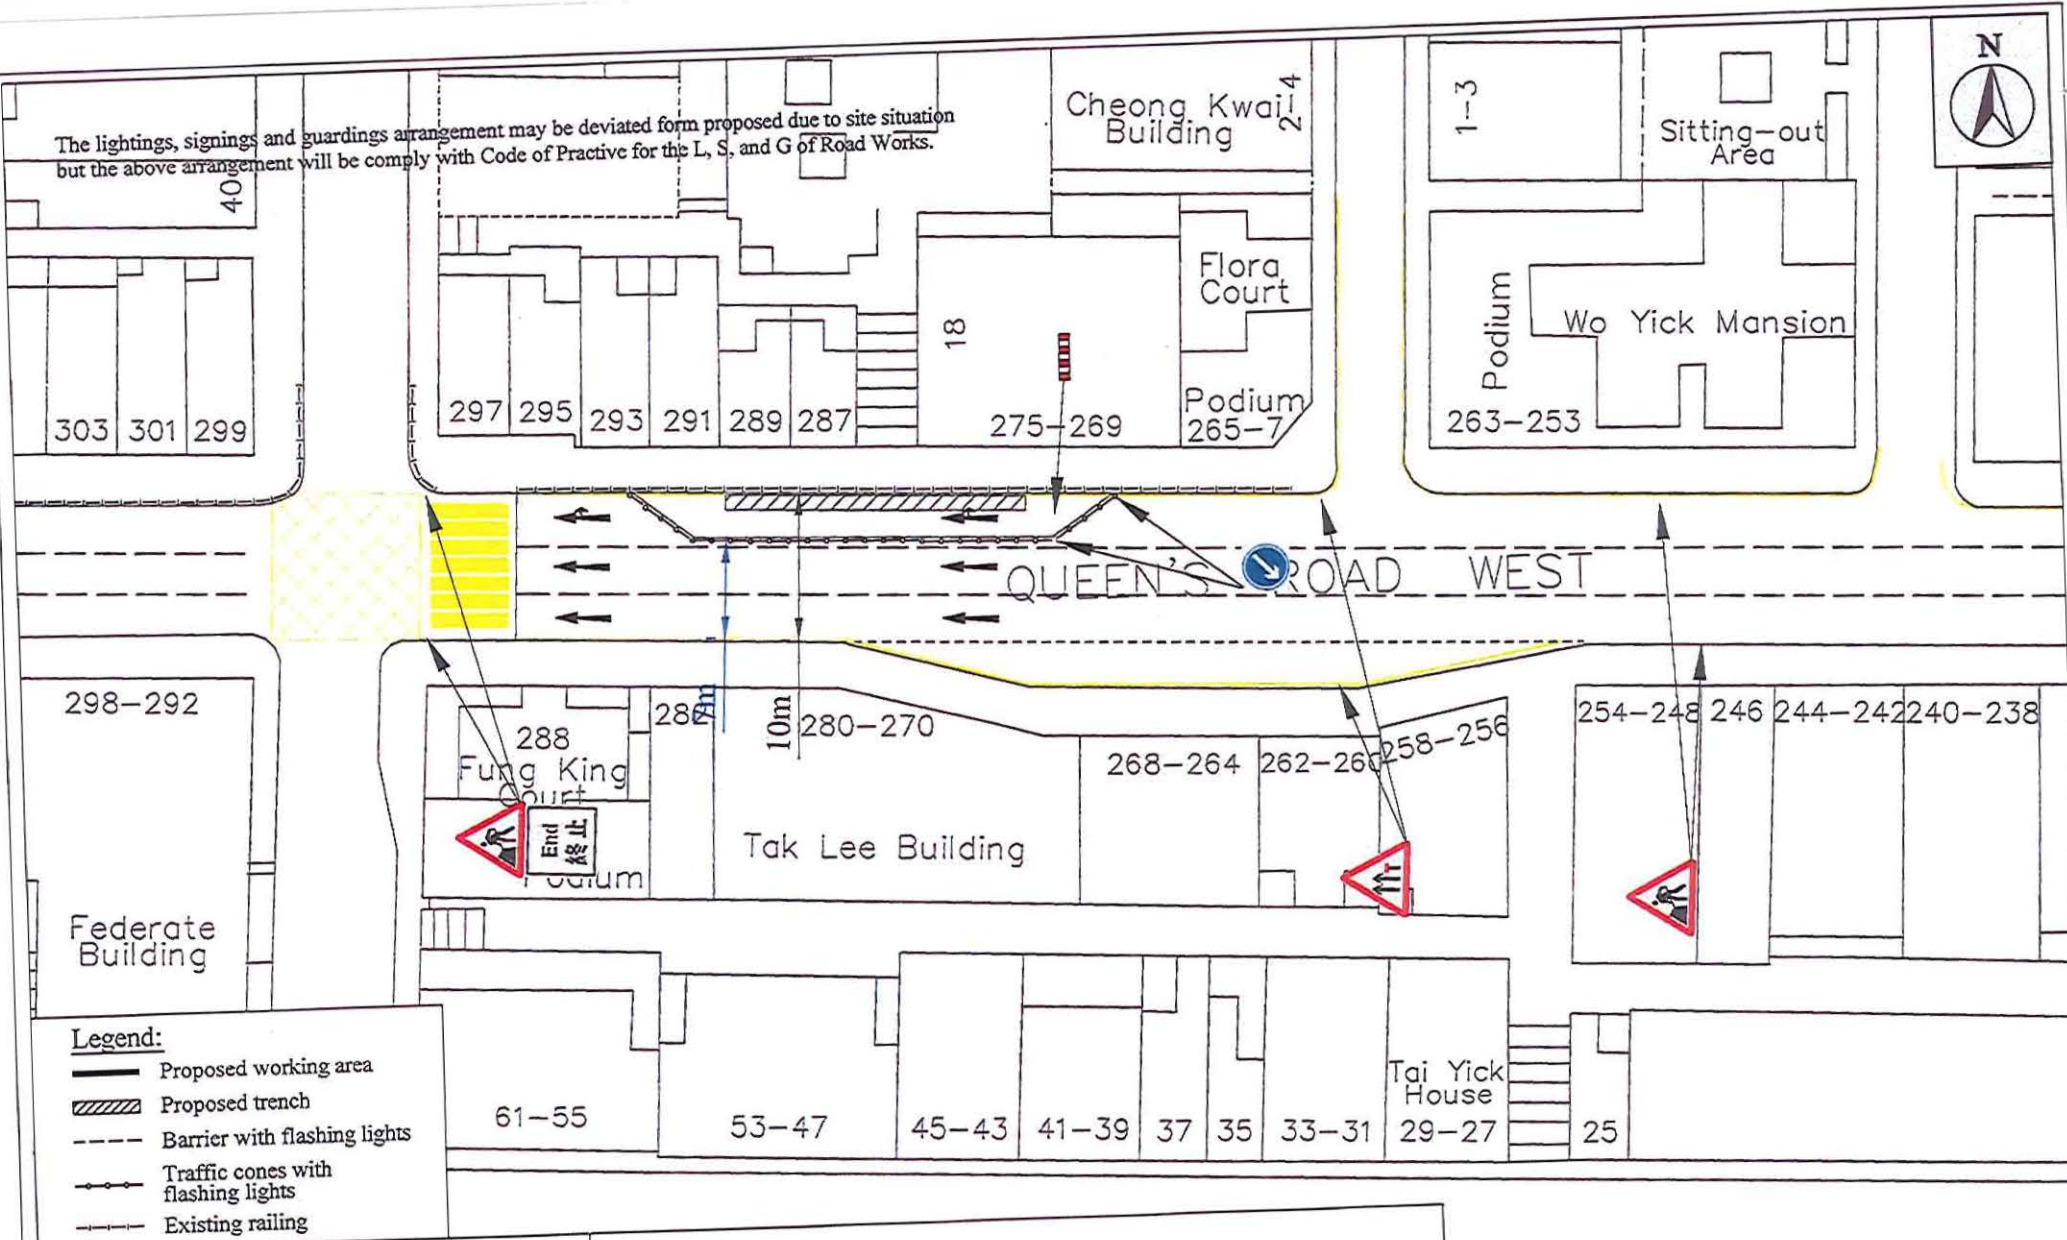

Legend:

- Proposed working area
- Proposed trench
- Barrier with flashing lights
- Traffic cones with flashing lights
- Existing railing

CONTRACTOR:



PUI HING CONSTRUCTION CO., LTD

SCALE: 1:500

SURVEY MAP NO:
11SW07B

DATE:

PLAN ID: 11

WORK: LAY CABLE

LOCATION:

1-13 KWAI HEUNG STREET

REF. NO: W/14/0003


DRAWN BY:

CHECK BY:


30 28 26 24 22 20 18 16 14 12

Phase 14

The lightings, signings and guardings arrangement may be deviated from proposed due to site situation but the above arrangement will be comply with Code of Practice for the L, S, and G of Road Works.

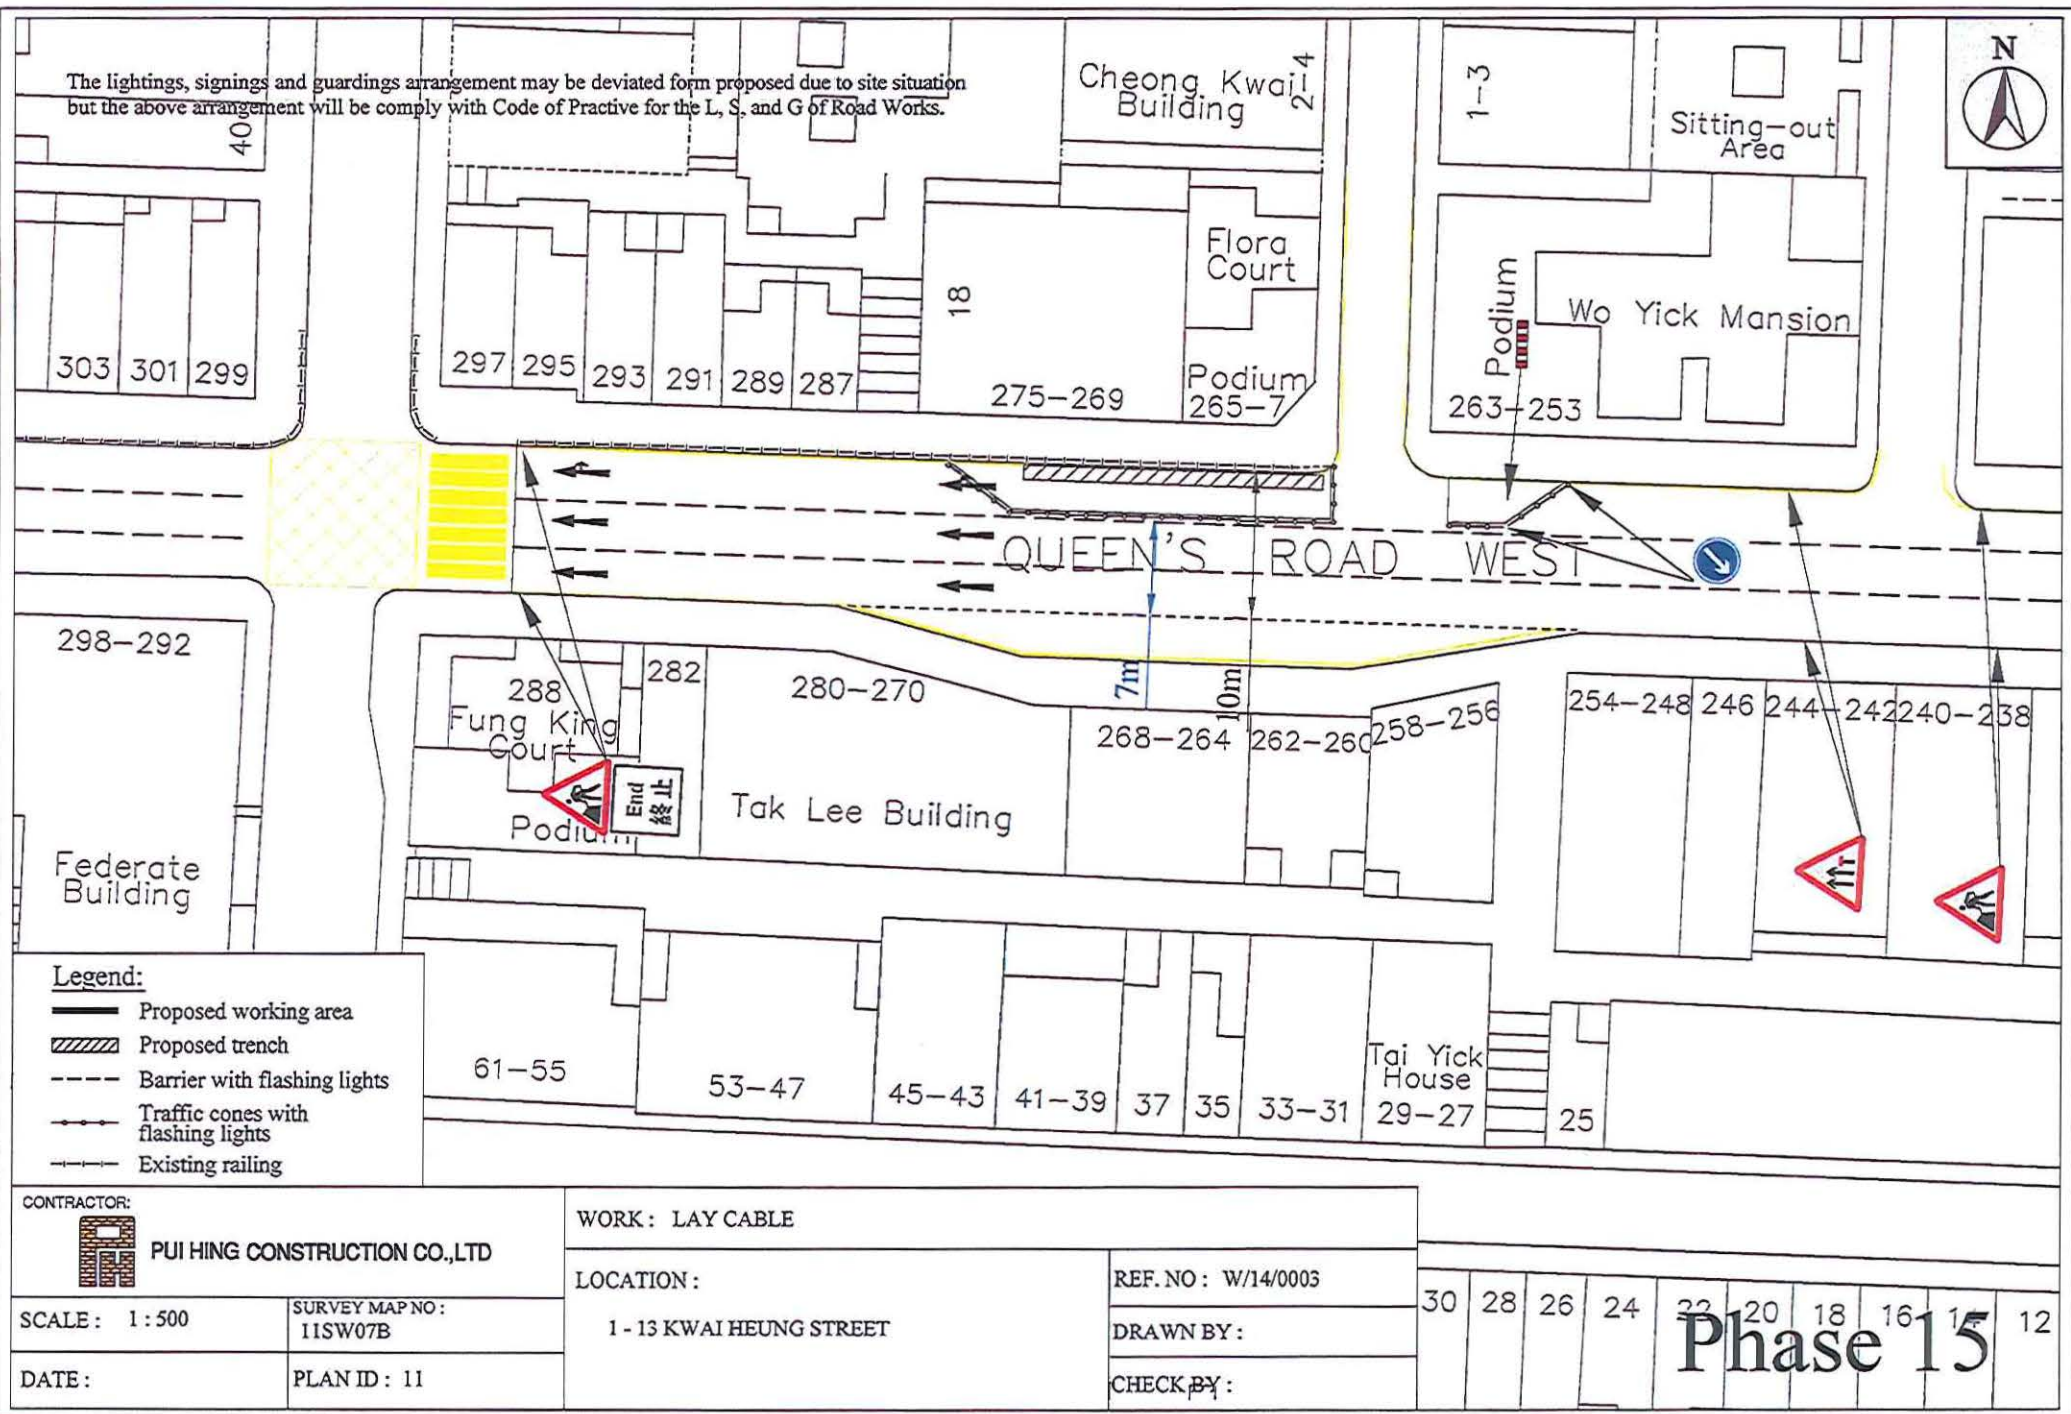

The lightings, signings and guardings arrangement may be deviated from proposed due to site situation but the above arrangement will be comply with Code of Practice for the T, S, and G of Road Works.

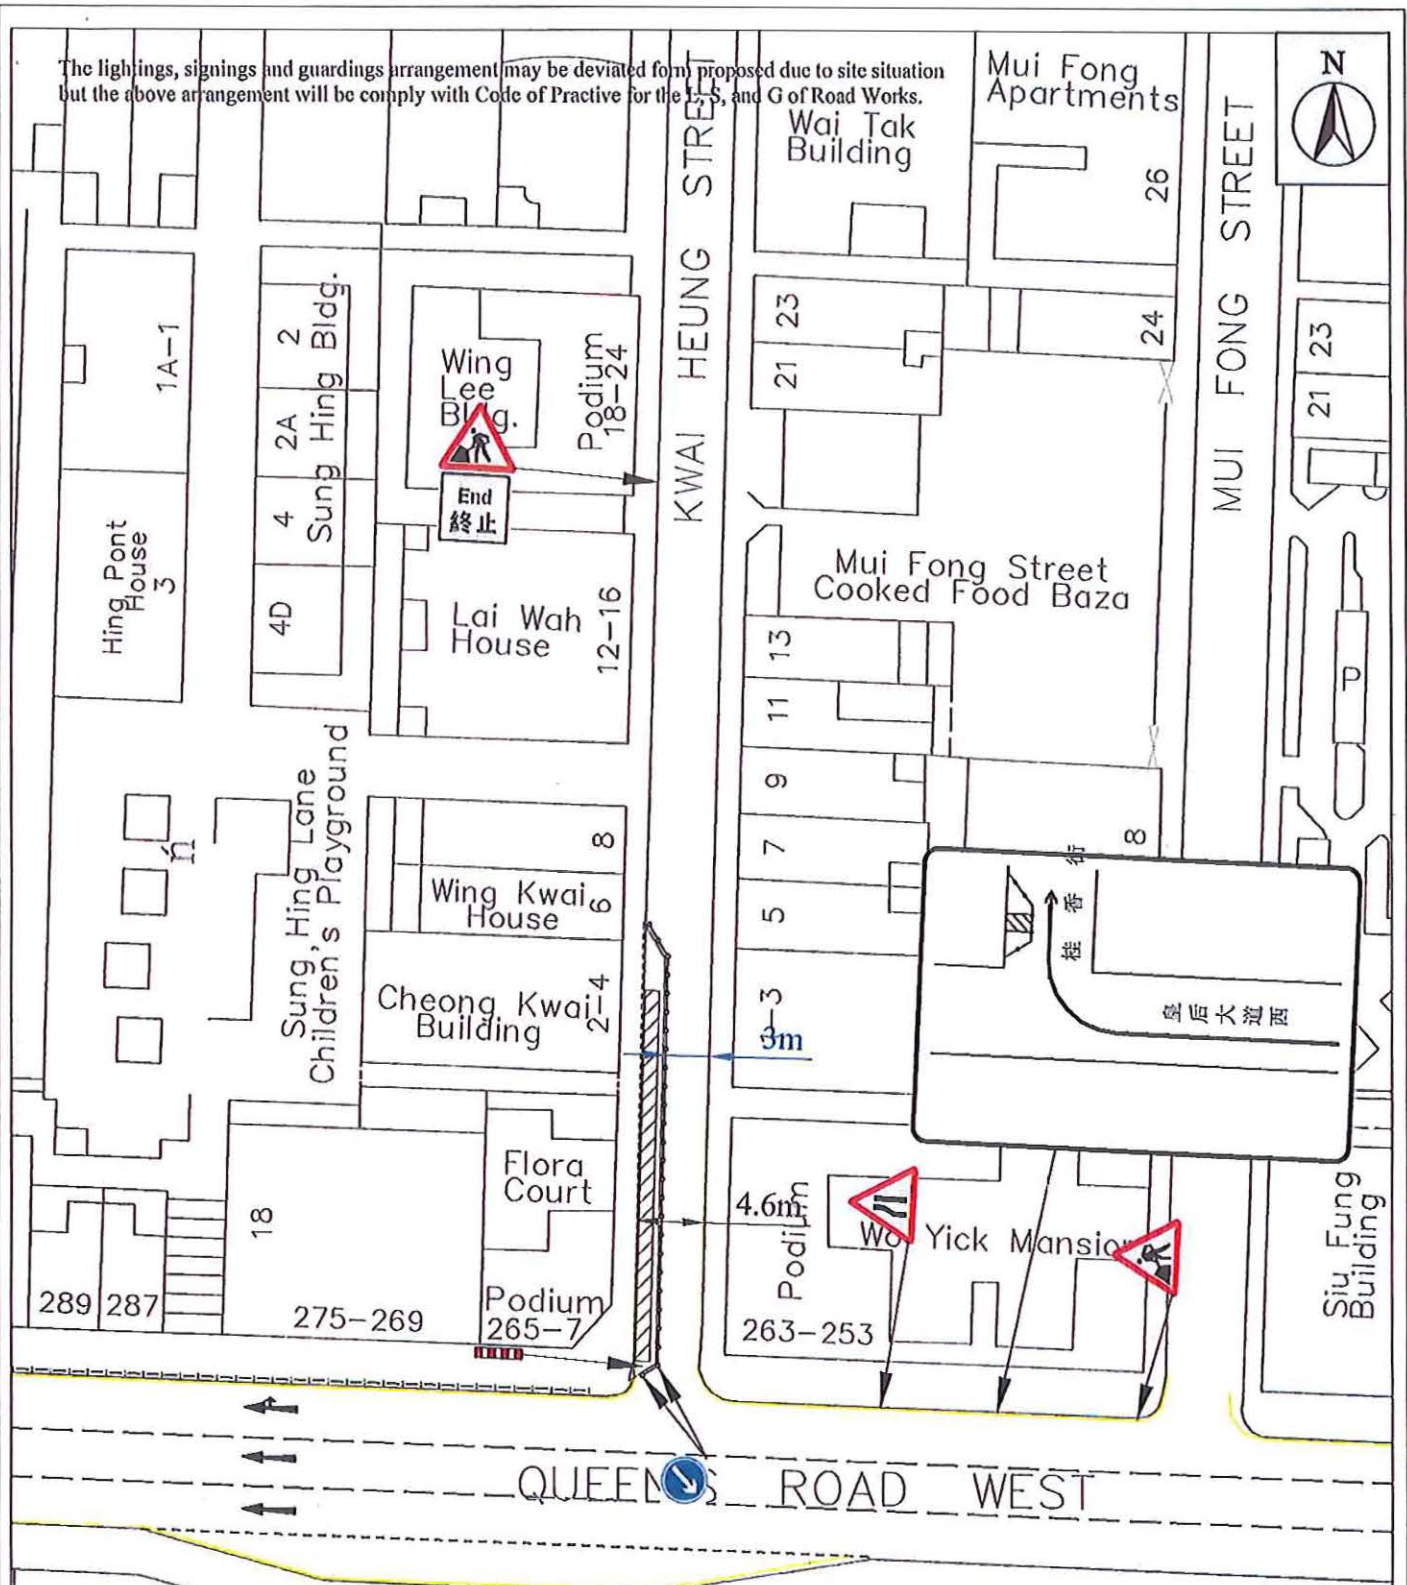

Legend:

- Proposed working area
- Proposed trench
- Barrier with flashing lights
- Traffic cones with flashing lights
- Existing railing

Tak Lee Building
Phase 16

CONTRACTOR:



PUI HING CONSTRUCTION CO., LTD

WORK: LAY CABLE

LOCATION:

1 - 13 KWAI HEUNG STREET

REF. NO: W/14/0003

DRAWN BY:

CHECK BY:


SCALE: 1:500

SURVEY MAP NO:
11SW07B

DATE:

PLAN ID: 11

The lightings, signings and guardings arrangement may be deviated from proposed due to site situation but the above arrangement will be comply with Code of Practice for the T.S. and G of Road Works.

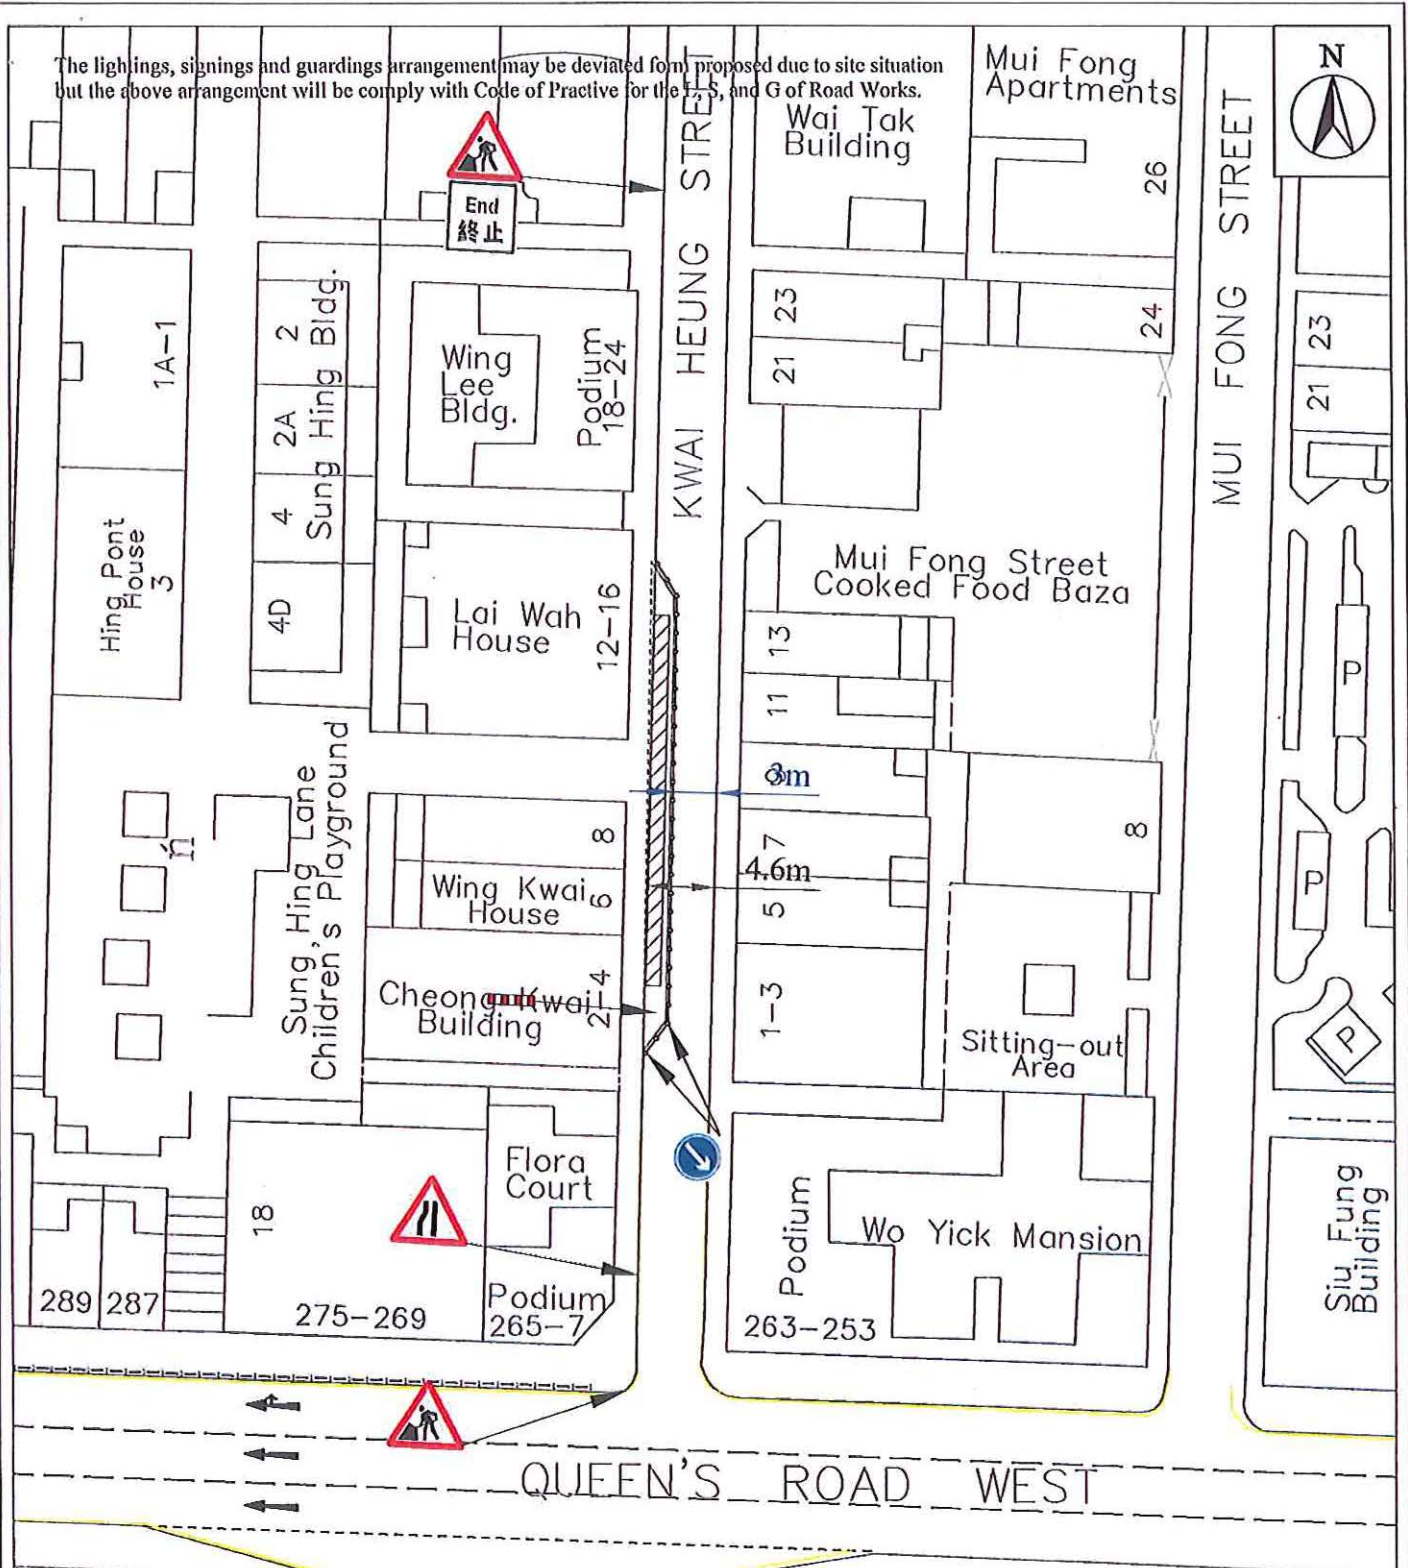

QUEEN'S ROAD WEST

Legend:

- Proposed working area
- Proposed trench
- Barrier with flashing lights
- Traffic cones with flashing lights
- Existing railing

Tak Lee Building
Phase 17

CONTRACTOR:



PUI HING CONSTRUCTION CO., LTD

WORK : LAY CABLE

LOCATION :

1 - 13 KWAI HEUNG STREET

REF. NO : W/14/0003

DRAWN BY :

CHECK BY :


SCALE : 1 : 500

SURVEY MAP NO :
11SW07B

DATE :

PLAN ID : 11

The lightings, signings and guardings arrangement may be deviated from proposed due to site situation but the above arrangement will be comply with Code of Practice for the T.S. and G of Road Works.

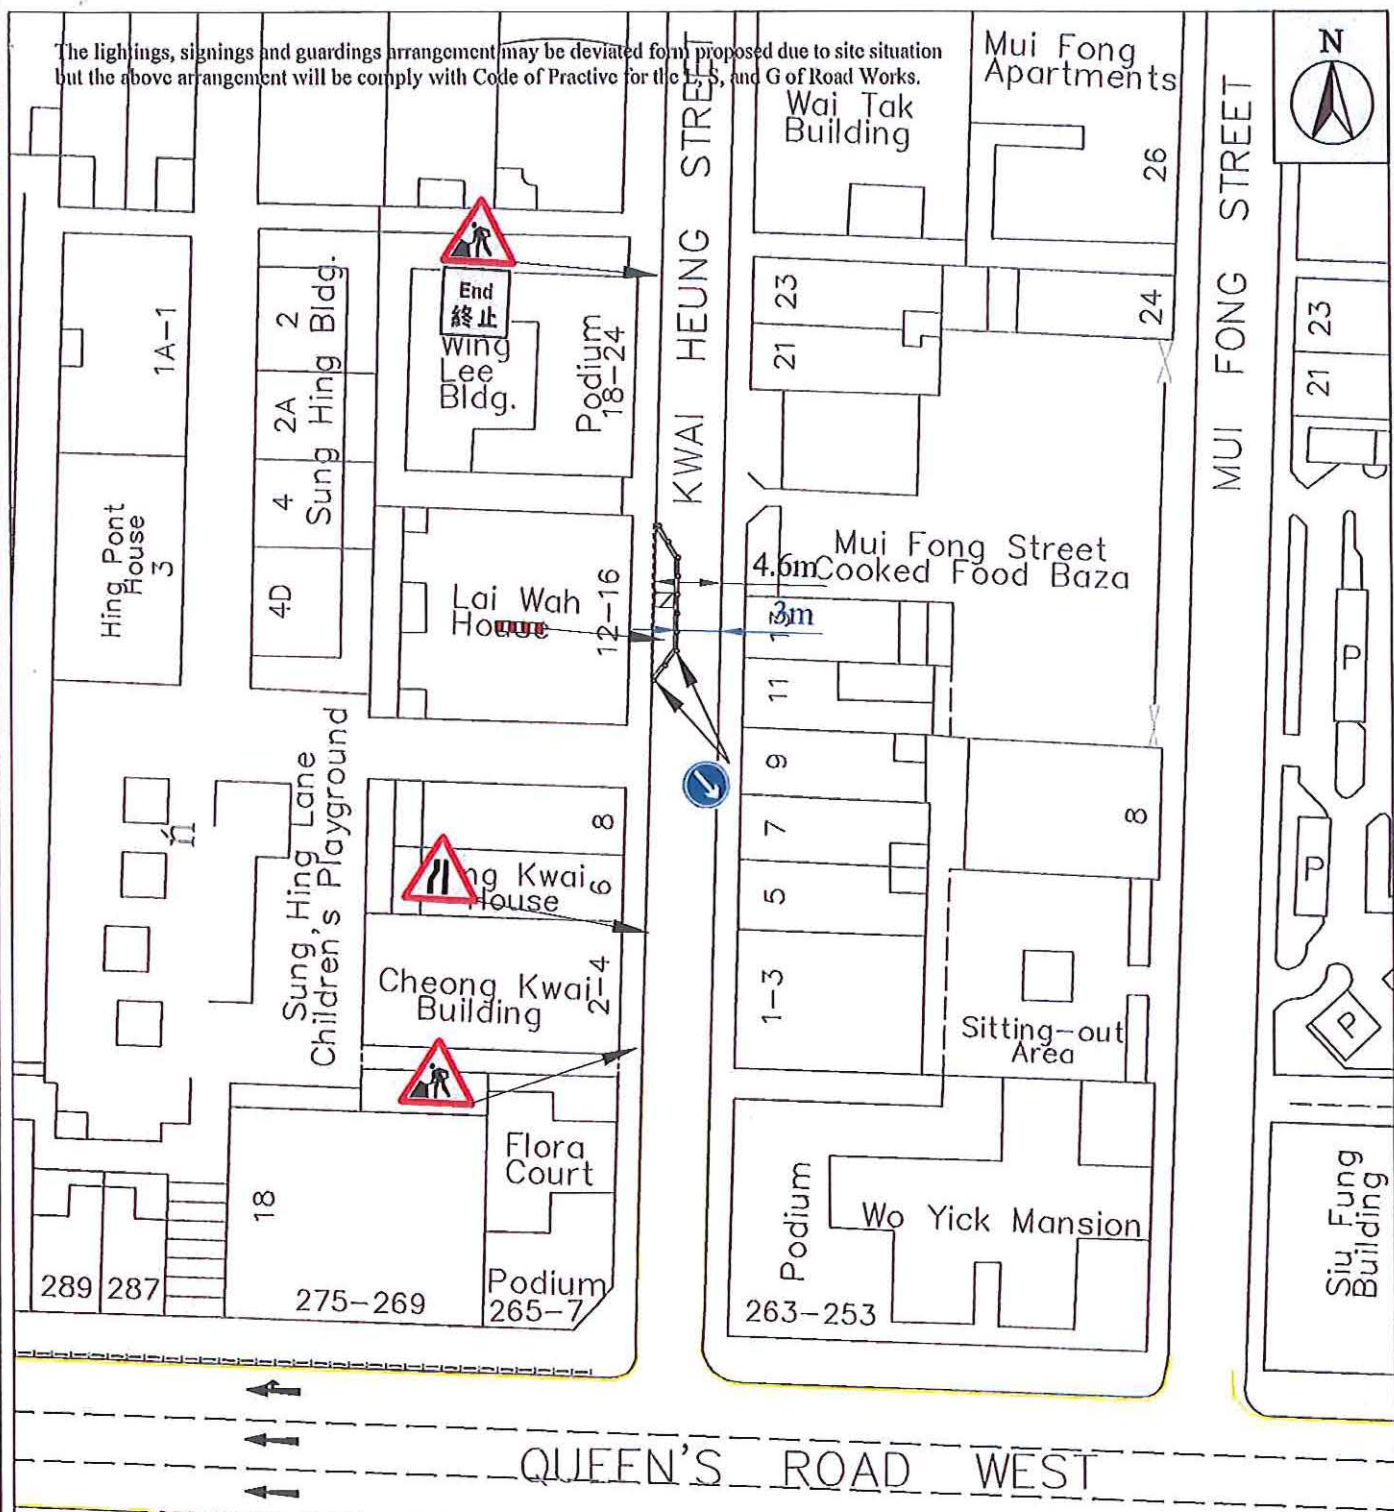

Legend:

- Proposed working area
- Proposed trench
- Barrier with flashing lights
- Traffic cones with flashing lights
- Existing railing

CONTRACTOR:



PUI HING CONSTRUCTION CO., LTD

WORK: LAY CABLE

LOCATION:

1 - 13 KWAI HEUNG STREET

REF. NO : W/14/0003

DRAWN BY :

CHECK BY :

SCALE: 1 : 500


SURVEY MAP NO:
11SW07B

DATE:

PLAN ID : 11

Tak Lee Building
Phase 18

The lightings, signings and guardings arrangement may be deviated from proposed due to site situation but the above arrangement will be comply with Code of Practice for the T.S. and G of Road Works.

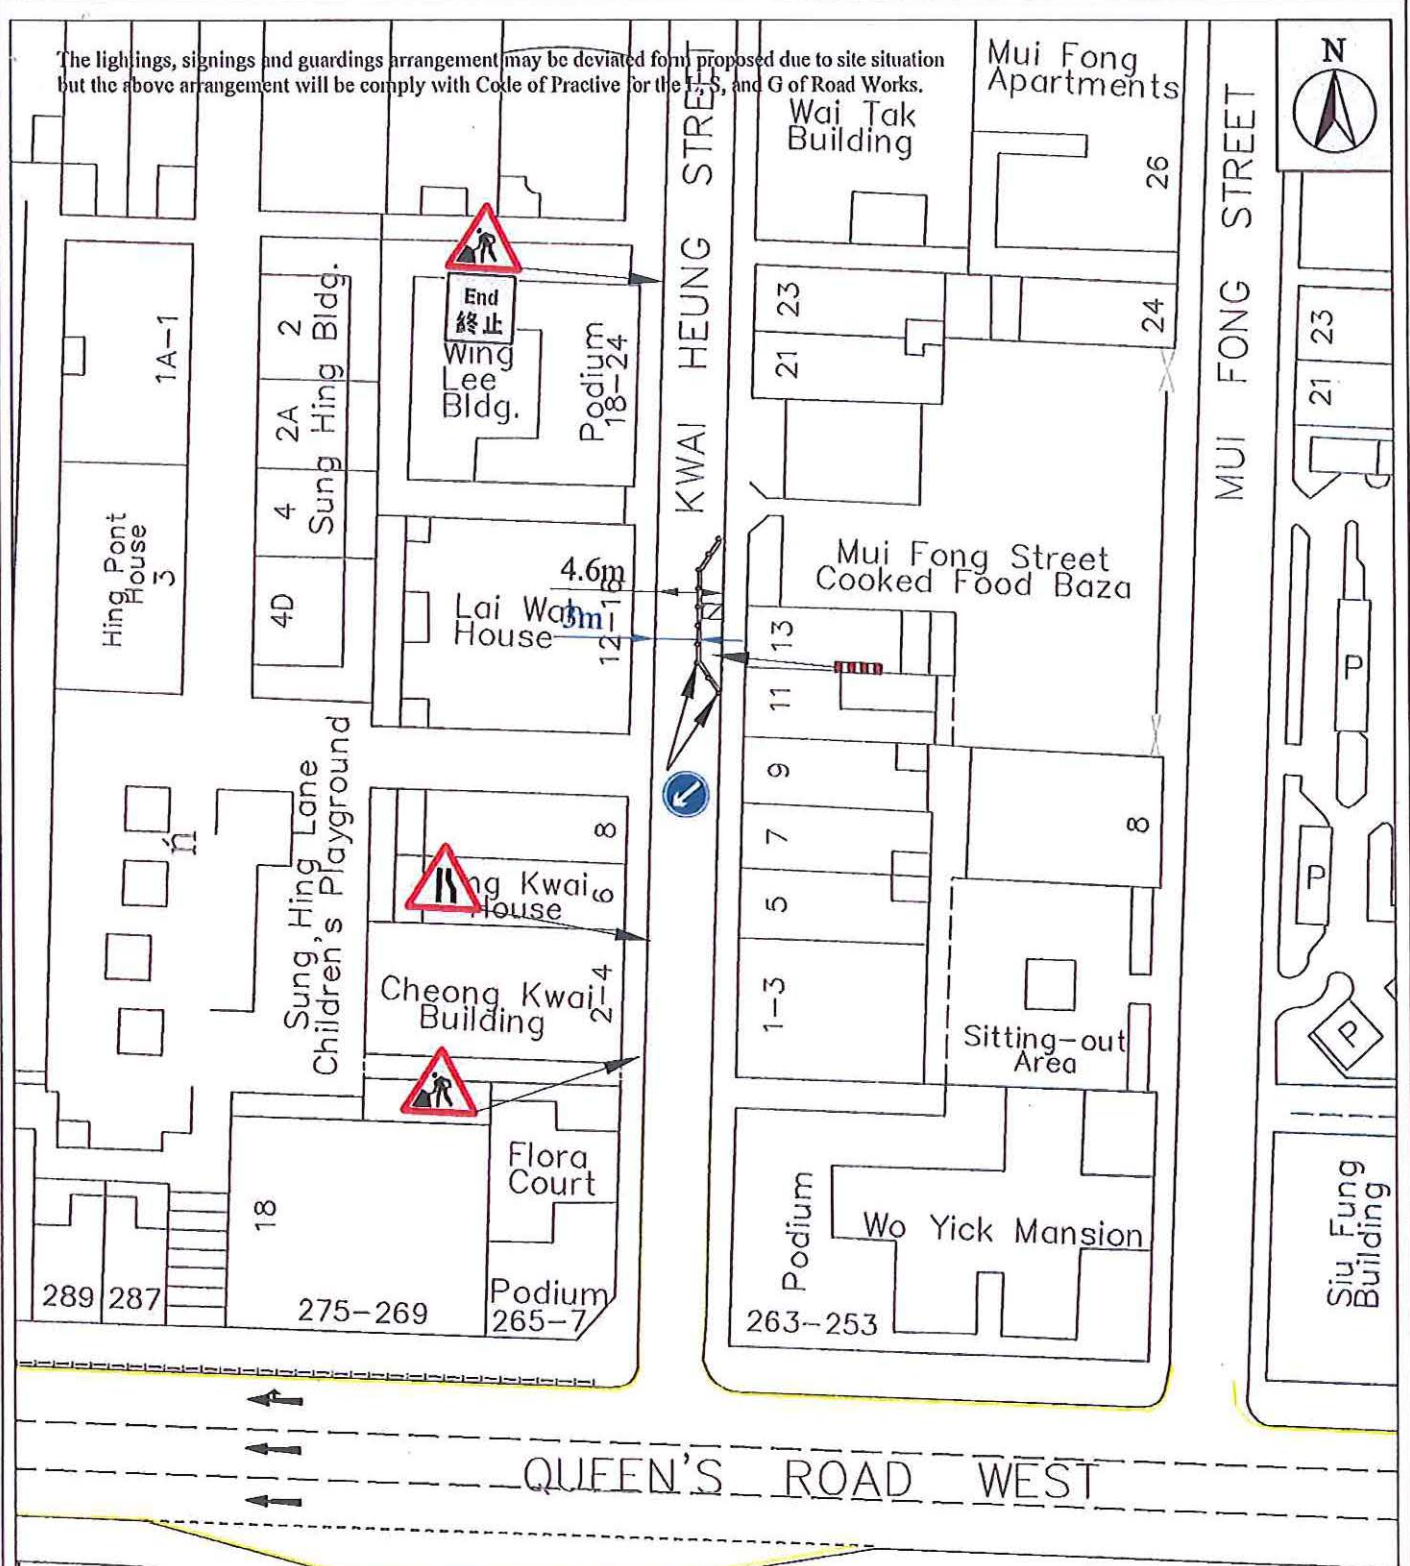

Legend:

- Proposed working area
- Proposed trench
- Barrier with flashing lights
- Traffic cones with flashing lights
- Existing railing

Tak Lee Building
Phase 19

CONTRACTOR:



PUI HING CONSTRUCTION CO.,LTD

WORK : LAY CABLE

LOCATION :

1 - 13 KWAI HEUNG STREET

REF. NO : W/14/0003

DRAWN BY :

CHECK BY :


SCALE: 1 : 500

SURVEY MAP NO :
11SW07B

DATE :

PLAN ID : 11

The lightings, signings and guardings arrangement may be deviated from proposed due to site situation but the above arrangement will be comply with Code of Practice for the L.S. and G of Road Works.

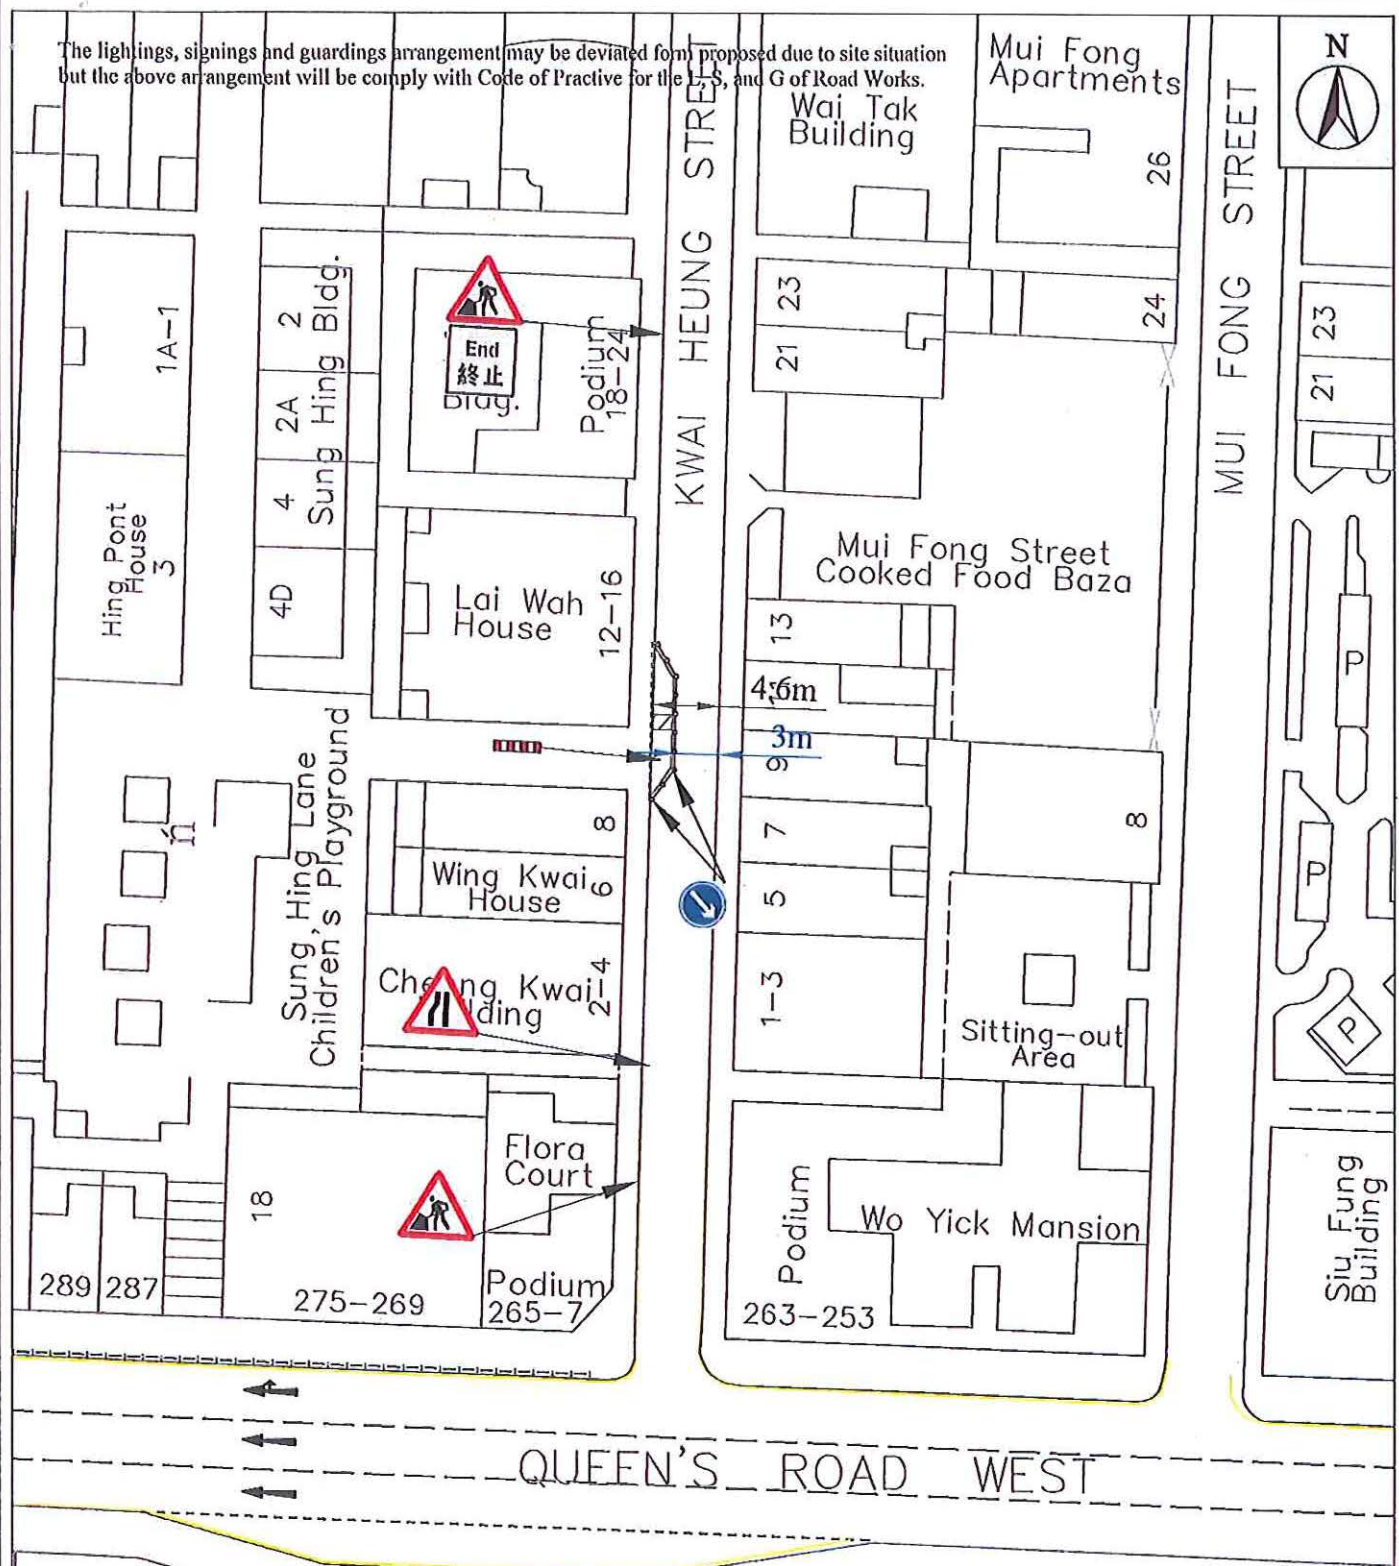

Legend:

- Proposed working area
- Proposed trench
- Barrier with flashing lights
- Traffic cones with flashing lights
- Existing railing

CONTRACTOR:



PUI HING CONSTRUCTION CO.,LTD

WORK: LAY CABLE

LOCATION:

1 - 13 KWAI HEUNG STREET

REF. NO : W/14/0003

DRAWN BY :

CHECK BY :

SCALE: 1:500


SURVEY MAP NO:
11SW07B

DATE:

PLAN ID: 11

Tak Lee Building
Phase 20

The lightings, signings and guardings arrangement may be deviated from proposed due to site situation but the above arrangement will be comply with Code of Practice for the L.S. and G of Road Works.

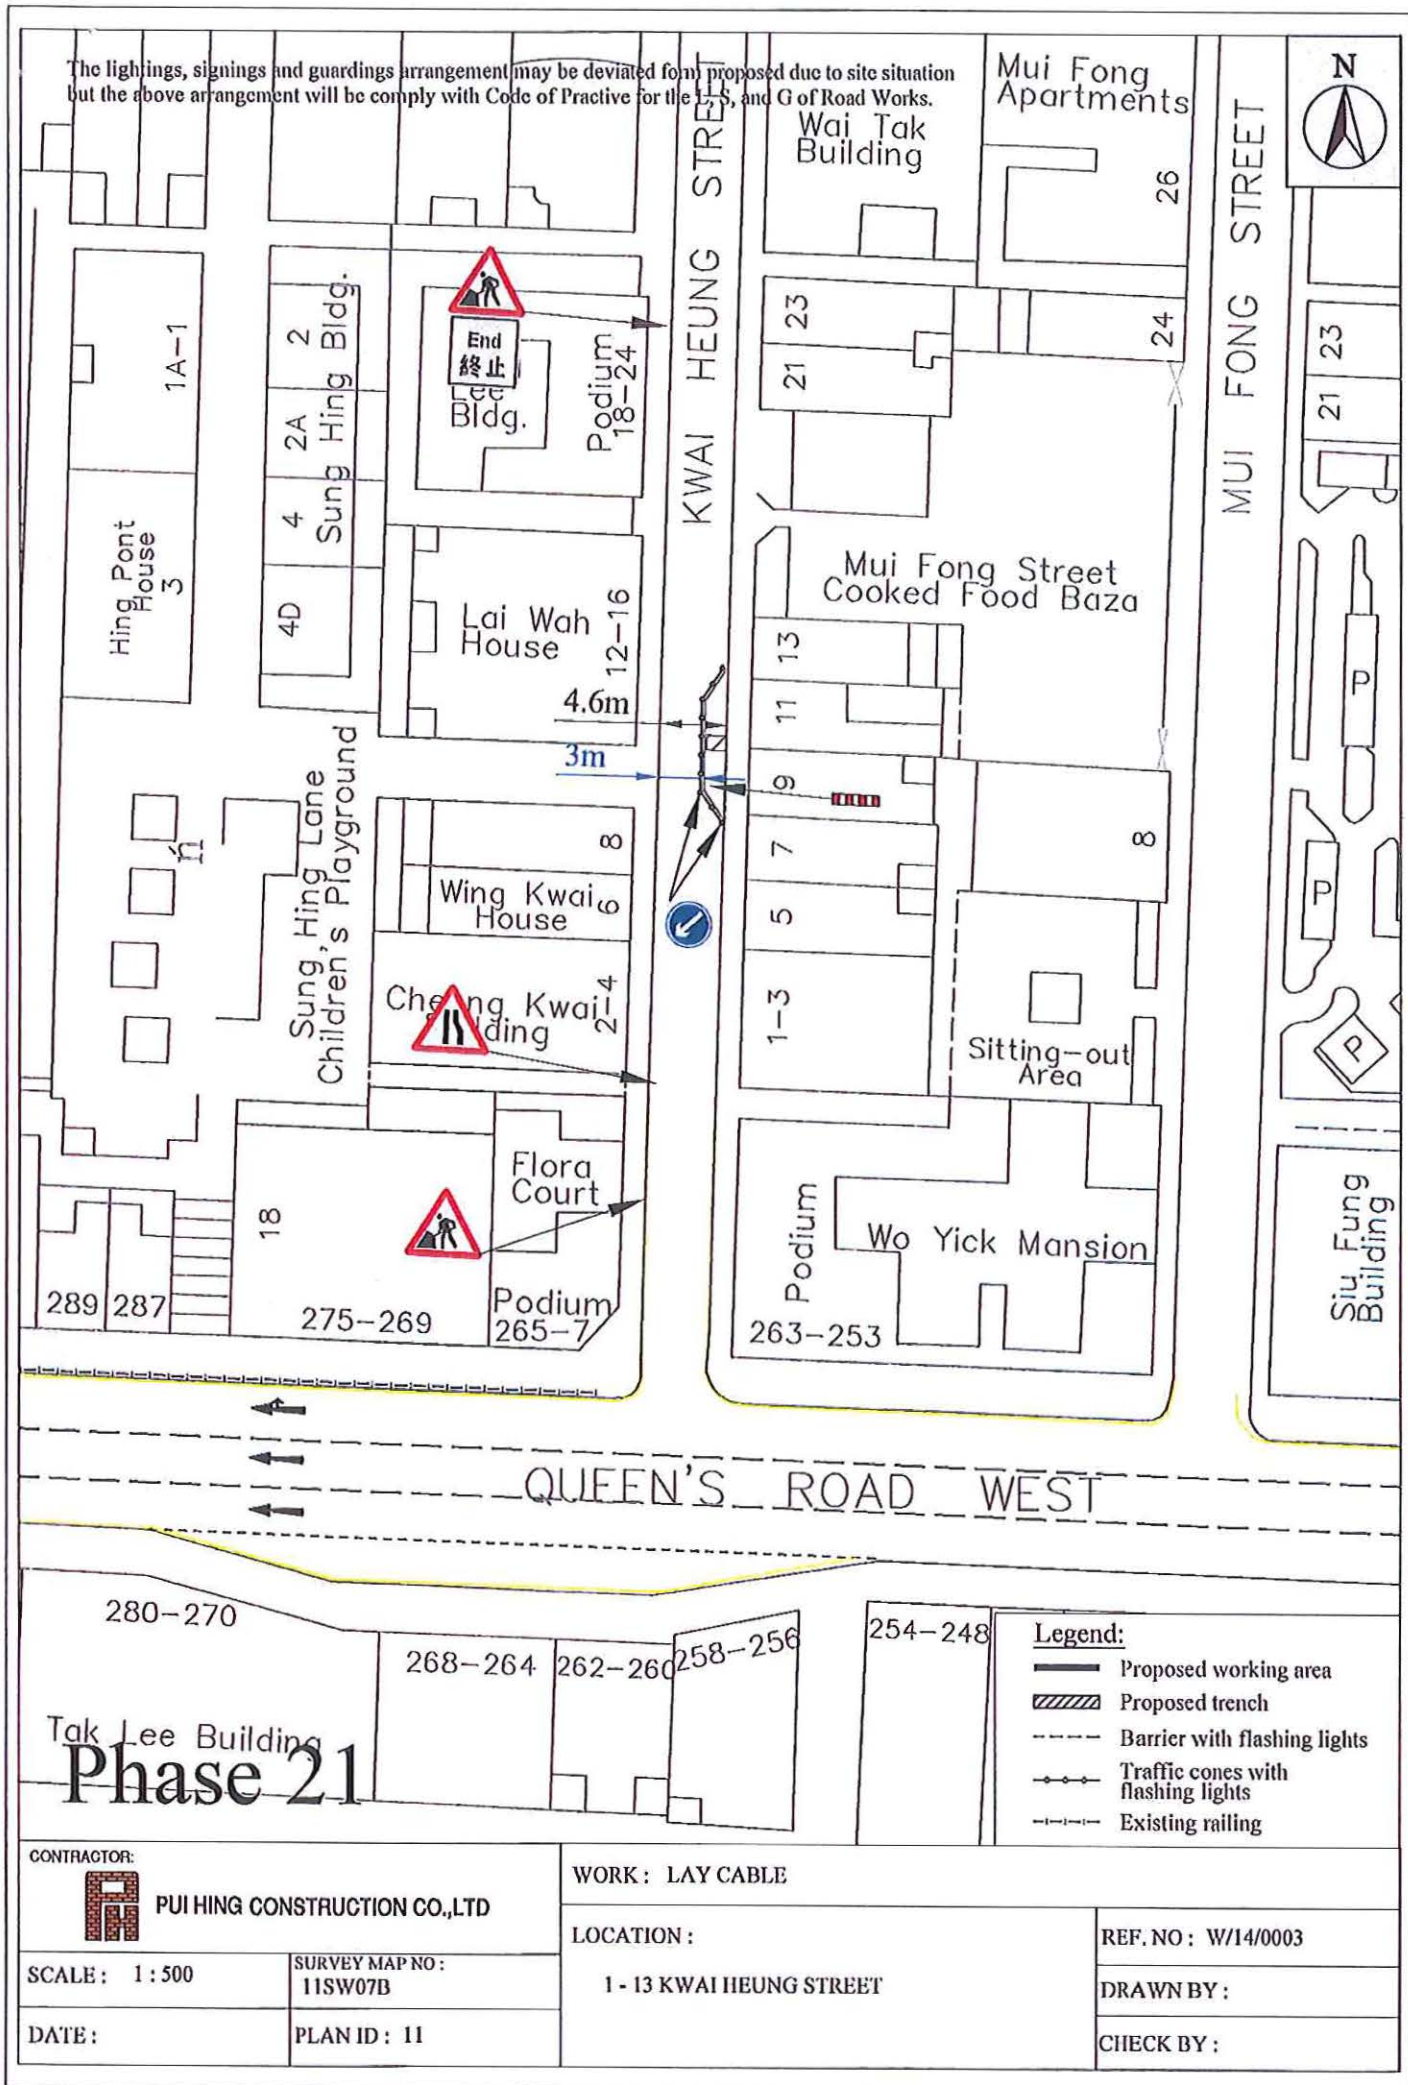

CONTRACTOR:



PUI HING CONSTRUCTION CO.,LTD

SCALE: 1 : 500

SURVEY MAP NO:
11SW07B

DATE:

PLAN ID: 11

WORK: LAY CABLE

LOCATION:


1 - 13 KWAI HEUNG STREET

REF. NO: W/14/0003

DRAWN BY:

CHECK BY:

The lightings, signings and guardings arrangement may be deviated from proposed due to site situation but the above arrangement will be comply with Code of Practice for the T.S. and G of Road Works.

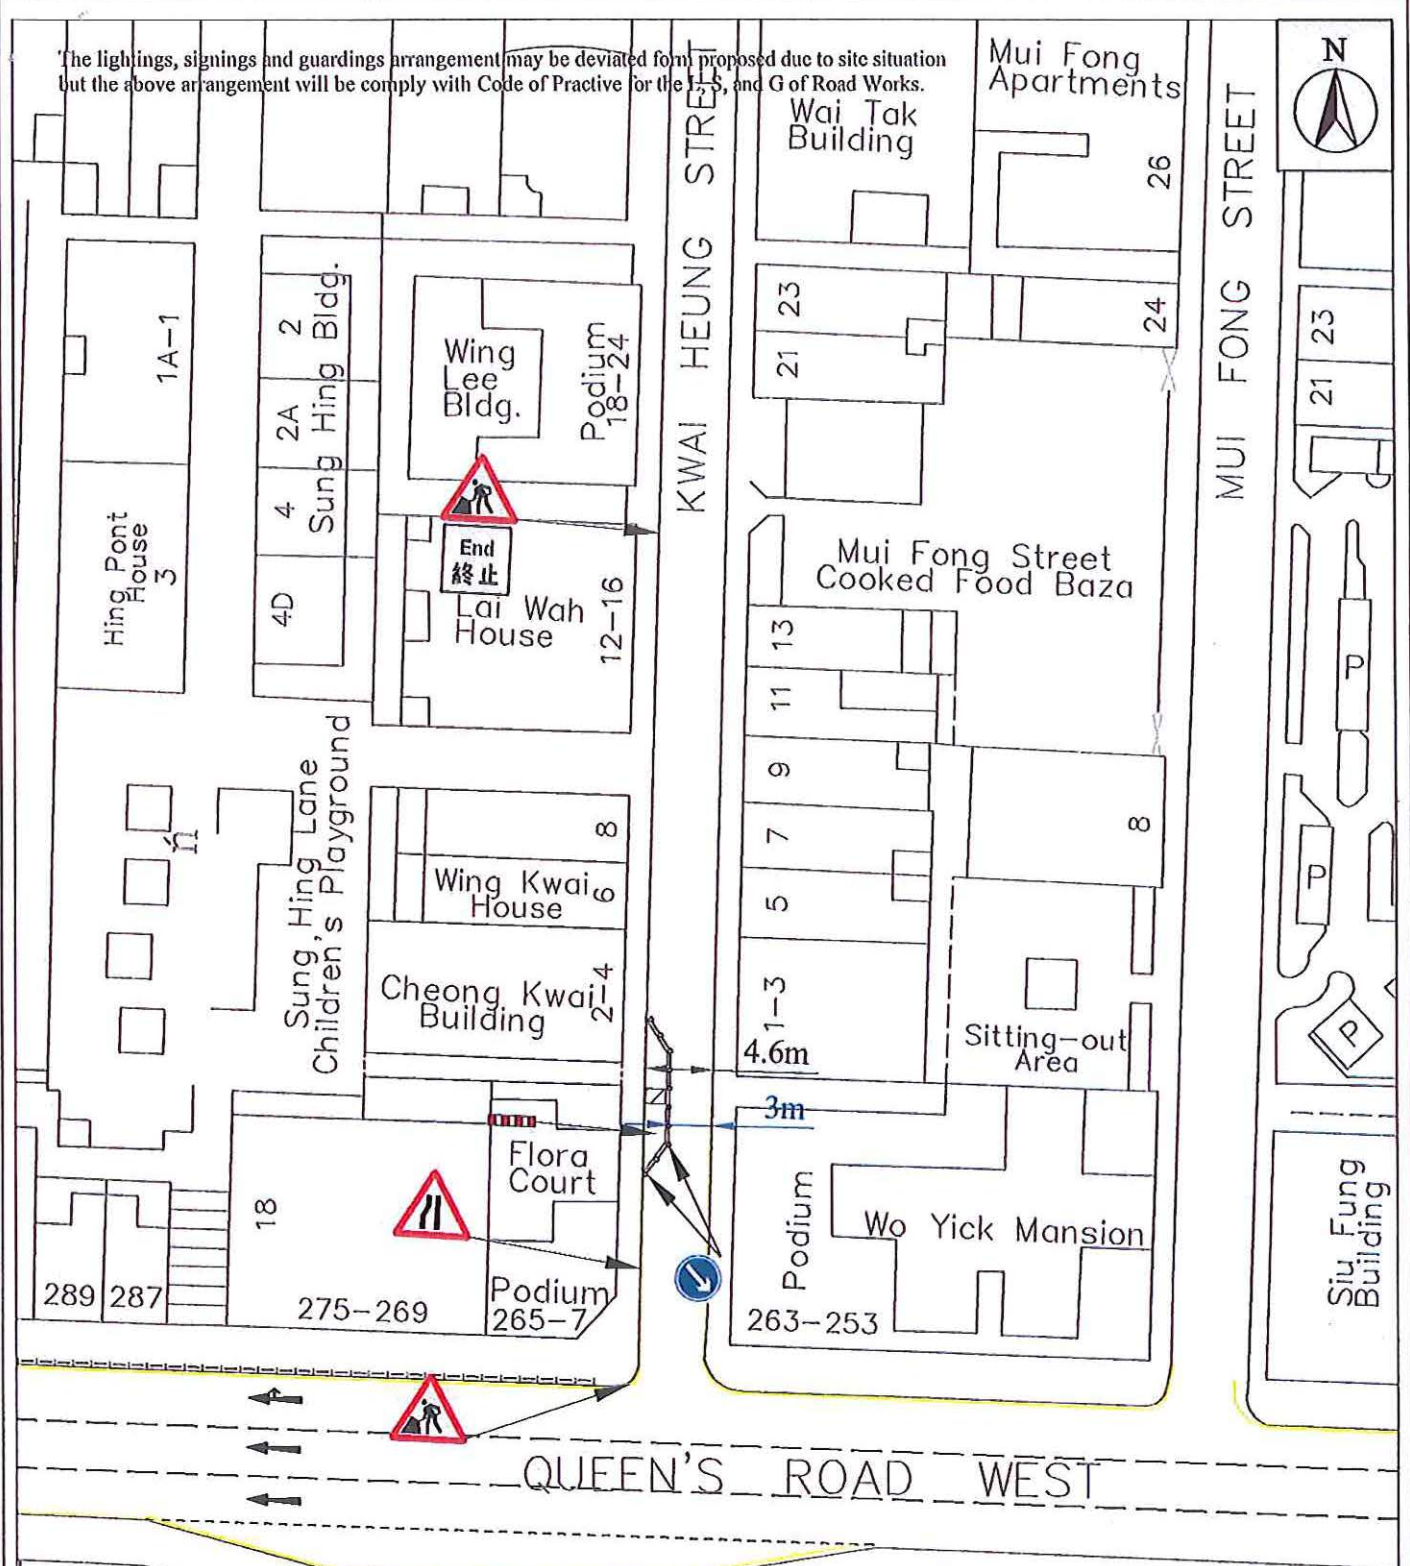

Legend:

- Proposed working area
- Proposed trench
- Barrier with flashing lights
- Traffic cones with flashing lights
- Existing railing

Tak Lee Building
Phase 22

CONTRACTOR:



PUI HING CONSTRUCTION CO., LTD

WORK : LAY CABLE

LOCATION :

1 - 13 KWAI HEUNG STREET

REF. NO : W/14/0003

DRAWN BY :

CHECK BY :


SCALE : 1 : 500

SURVEY MAP NO :
11SW07B

DATE :

PLAN ID : 11

The lightings, signings and guardings arrangement may be deviated from proposed due to site situation but the above arrangement will be comply with Code of Practice for the L.S. and G of Road Works.

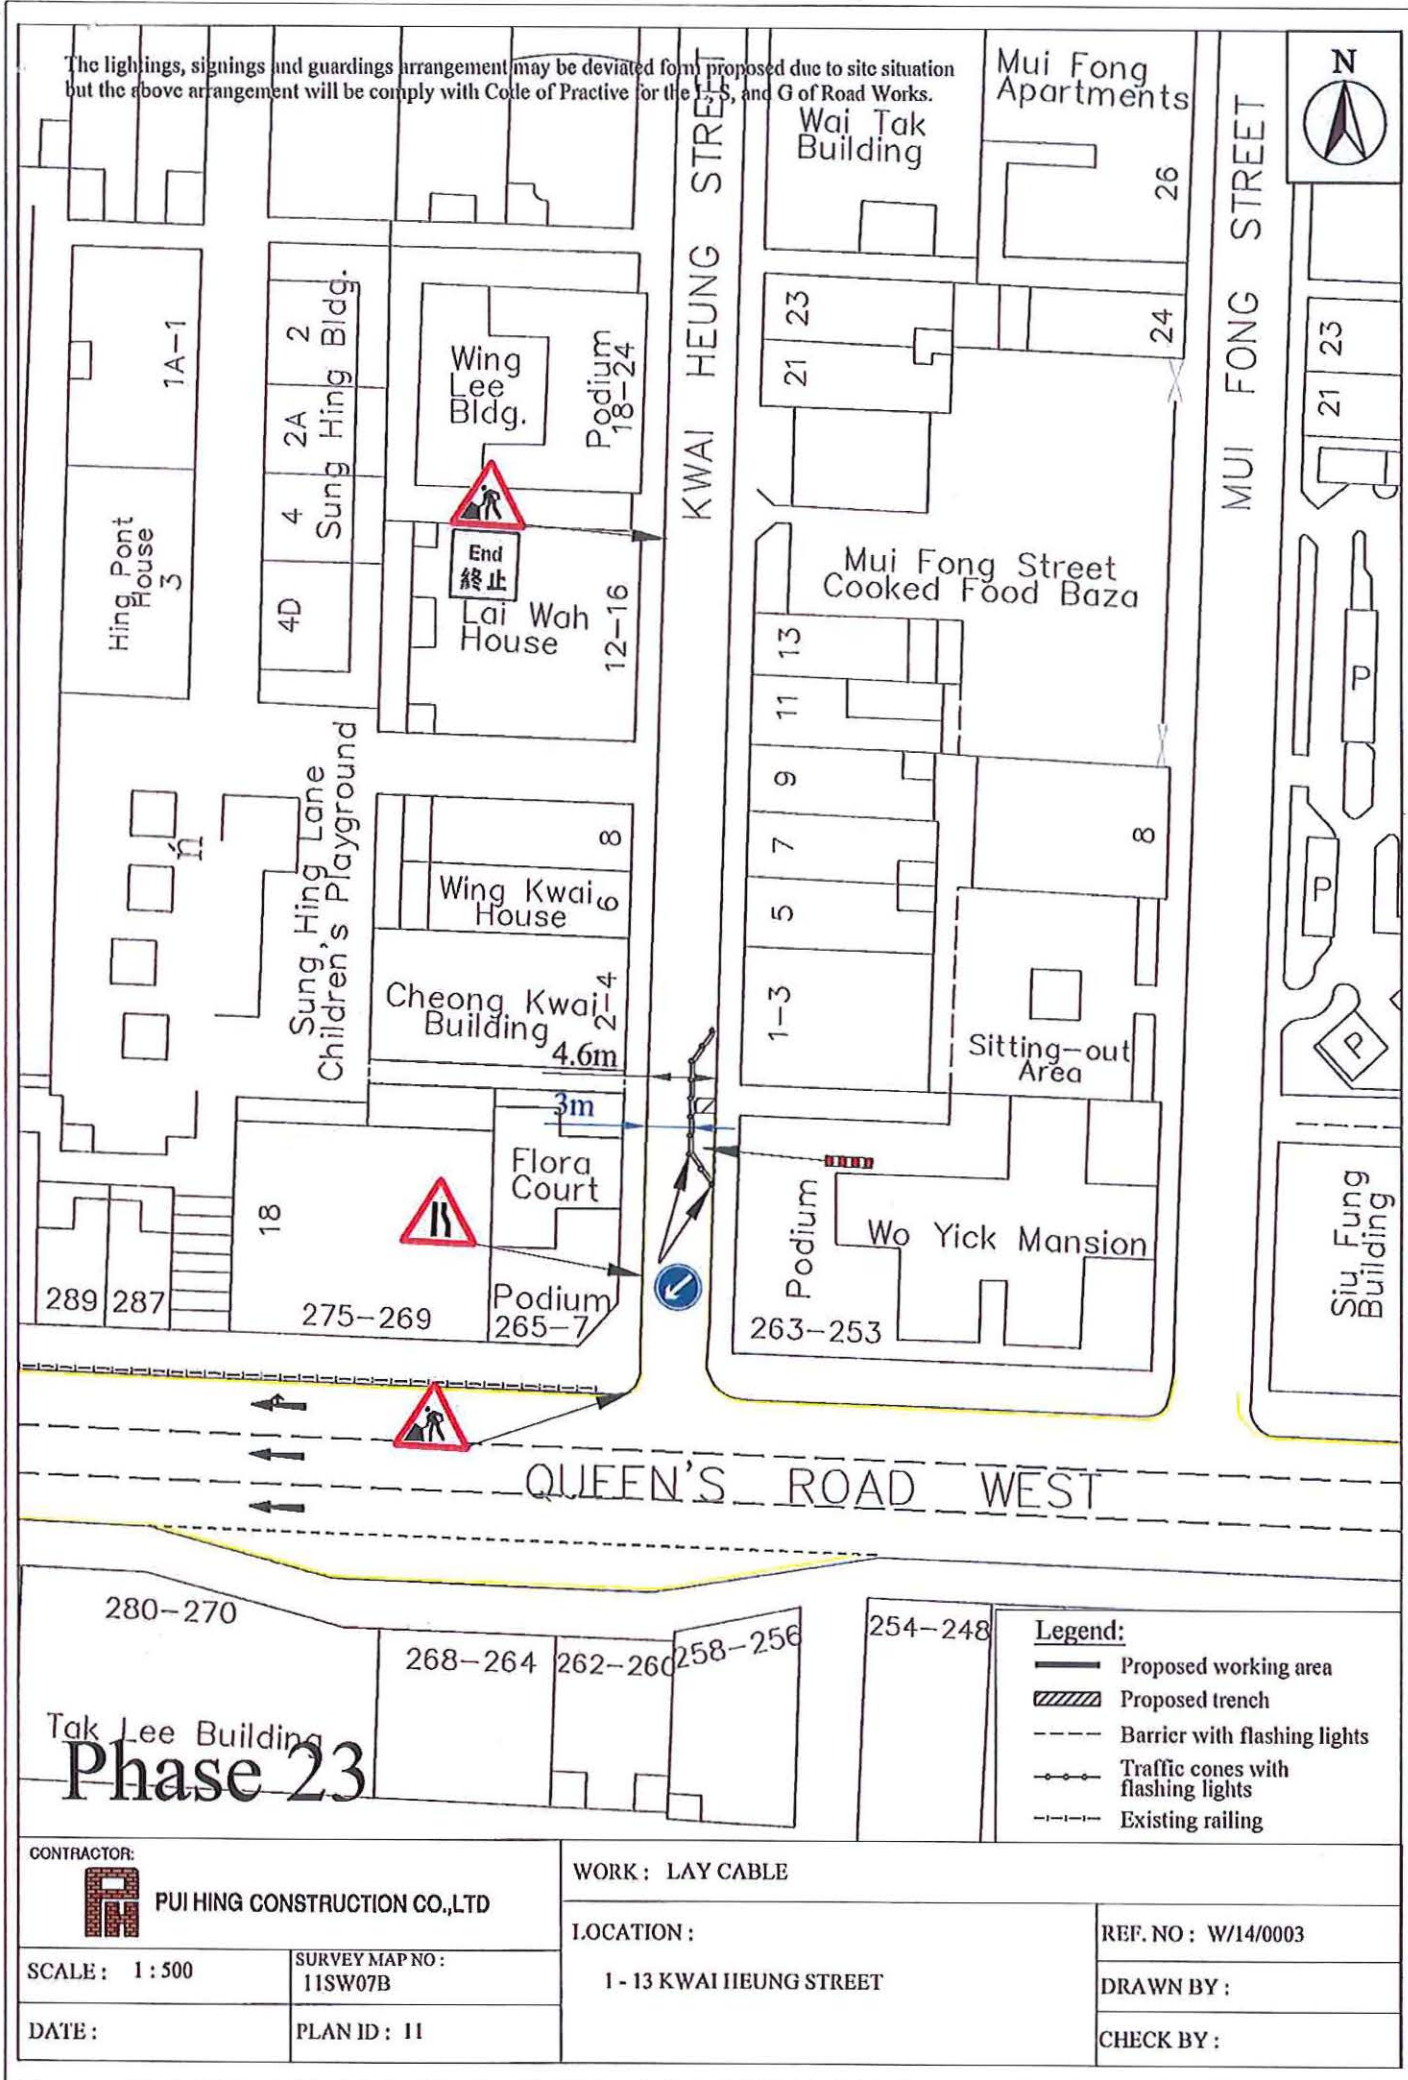

Legend:

- Proposed working area
- ▨ Proposed trench
- Barrier with flashing lights
- Traffic cones with flashing lights
- - - Existing railing

CONTRACTOR:



PUI HING CONSTRUCTION CO.,LTD

SCALE: 1 : 500

SURVEY MAP NO:
11SW07B

DATE:

PLAN ID: 11

WORK: LAY CABLE

LOCATION:

1 - 13 KWAI HEUNG STREET

REF. NO: W/14/0003

DRAWN BY:

CHECK BY: